

- LEGEND**
- CONCRETE CURB, TWO-STAGE BARRIER (TOWN STD. 6-1)
 - CONCRETE CURB, MOUNTABLE (OPSD 600.060)
 - CONCRETE CURB, BARRIER FREE (OPSD 600.060 W/ DROPPED CURB)
 - PROPOSED STORM SEWER AND MANHOLE
 - PROPOSED SANITARY SEWER AND MANHOLE
 - EXISTING SEWER AND STORM MANHOLE
 - EXISTING SANITARY SEWER AND MANHOLE
 - AREA DRAIN
 - EXISTING SINGLE CATCHBASIN
 - EXISTING DOUBLE CATCHBASIN
 - EXISTING HYDRANT & VALVE
 - PROPOSED HYDRANT & VALVE
 - VALVE AND BOX
 - 2400mm VALVE CHAMBER (STD RH 402.010)
 - EX. TRANSFORMER
 - EX. STREET LIGHT
 - UNIT PAVING (BY OTHERS)
 - PEDESTRIAN CONCRETE PAVING (BY OTHERS)
 - VEHICULAR CONCRETE PAVING (BY OTHERS)
 - OAKVILLE PHASE 3A
 - 100mm WATER METER
 - BACKFLOW PREVENTER

- NOTES:**
- FOR DETAILS OF EXISTING SEWERS REFER TO PROJECT 12-370 PHASE 2 BY URBANTECH CONSULTING.
 - NEW WATER SERVICING TO BE BUILT WITH PHYSICAL SEPARATION FROM LIVE WATER SERVICING FOR TESTING PURPOSES.
 - ANY CONNECTION TO AN EXISTING SERVICE PREVIOUSLY INSTALLED SHALL BE SWABBED, FLUSHED AND SAMPLED BY THE REGION AT THE SOLE EXPENSE OF THE APPLICANT.

BENCHMARK NOTE:
ELEVATIONS HEREON ARE GEODETIC AND ARE REFERRED TO THE TOWN OF OAKVILLE BENCHMARK No. 34 LOCATED ON THE NORTH EAST SIDE OF 7TH LINE ROAD, MIDWAY BETWEEN HIGHWAY No. 5 AND UPPER MIDDLE ROAD, DESCRIBED AS A CONCRETE MONUMENT WITH A BRASS CAP 4.6 METRES EAST OF THE BACK OF CURB ON THE EAST SIDE OF TRAFALGAR ROAD, OPPOSITE BUILDING No. 2274 TRAFALGAR ROAD, HAVING AN ELEVATION OF 162.517 METRES.

4	FUT. INVERTS ADDED AT SAN & STM CTRL MH	OCT. 27, 2020	T.L.
3	SECOND SITE PLAN SUBMISSION	SEPT. 29, 2020	T.L.
2	FIRST SITE PLAN SUBMISSION	JUL. 21, 2020	T.L.
1	DATE	BY	

BEC TRAFALGAR GP INC.
OAKVILLE PHASE 3B (BLOCK 13)
3220 WILLIAM COLTSON AVENUE

REGIONAL MUNICIPALITY OF HALTON
TOWN OF OAKVILLE


REGION NO. SP #####
MUNICIPAL PLANNING No. ##### SITE PLAN NO. SP-1312.010/02

REGIONAL APPROVAL
REGION DESIGN OF WATER &/OR WASTEWATER SERVICES APPROVED SUBJECT TO DETAIL CONSTRUCTION CONFORMING TO HALTON REGION STANDARDS & SPECIFICATIONS & LOCATION APPROVAL FROM AREA MUNICIPALITY.

urbantech
UrbanTech Consulting, A Division of Legatum Inc. Ltd.
2780 14th Avenue, Suite 201, Oakville, Ontario L6H 7T7
905-336-1000 Fax: 905-336-1001
www.urbantech.ca

SERVICING PLAN

DESIGNED: T.L. CHECKED: J.O. PROJECT No.: 18-600
DRAWN: T.L. DATE: SEPTEMBER 2020 SHEET No.:
SCALE: 1:250 DRAWING No.: **SP-1**

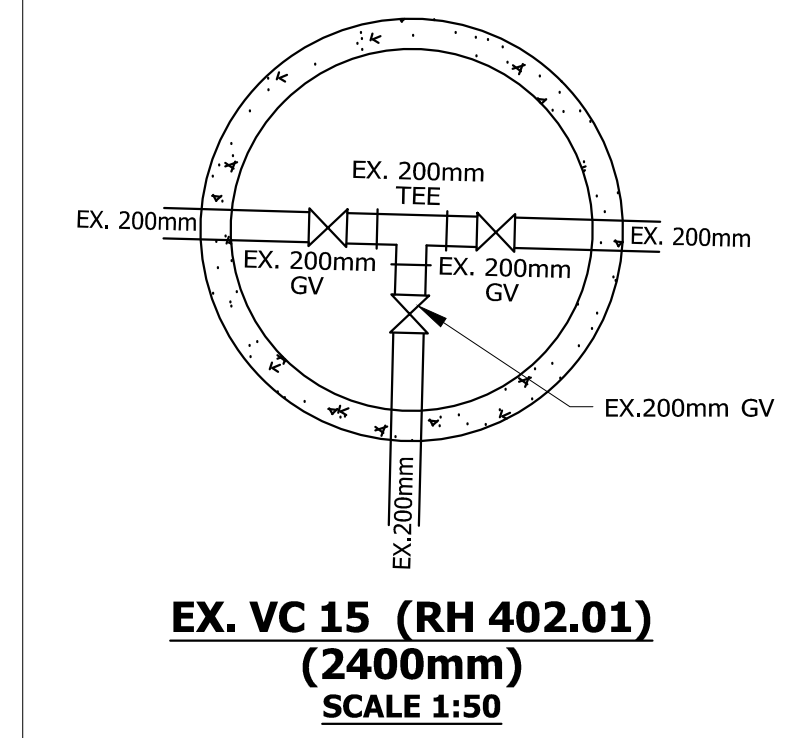

ANY CONNECTION TO AN EXISTING SERVICE PREVIOUSLY INSTALLED SHALL BE SWABBED, FLUSHED AND SAMPLED BY THE REGION AT THE SOLE EXPENSE OF THE APPLICANT.

REGIONAL BY-LAW No. 131-10, SECTION II, C. 14 (4)

The Applicant should be aware that the approval of the water system on private property is the responsibility of the Local Municipality. Regardless, the Applicant must ensure that the Region of Halton's standards and specifications are met (the *Water and Wastewater Linear Design Manual* may be obtained from the *Data Management Group* at 905-825-6032). Furthermore, all water quality tests must be completed to the Region of Halton's satisfaction, before the water supply can be turned on.