

Contractor shall check all dimensions on the work and report any discrepancy to the Landscape Architect before proceeding. All drawings and specifications are the property of the Landscape Architect and must be returned at the completion of the work. This drawing is not to be used for construction until signed by the Landscape Architect.

- LEGEND**
- PHASE LINE
 - PROPERTY LINE
 - LIMIT OF STRUCTURAL SLAB
 - 1.2m DECORATIVE METAL FENCE
 - 1.2m PRIVACY RAILING
 - 1.8m PATIO DIVIDERS
 - HANDRAILS
- SURFACING**
- UNIT PAVING (VEHICULAR ON SLAB) PROMENADE PLANK BY UNILOCK PATTERN: HERRINGBONE SIZE: 60CM X 20CM X 10CM COLOUR: GRANITE BLEND IL CAMPO
 - UNIT PAVING TYPE 1 (PEDESTRIAN ON SLAB) PROMENADE PLANK BY UNILOCK PATTERN: RUNNING BOND SIZE: 60CM X 20CM X 10CM COLOUR: OPAL
 - UNIT PAVING TYPE 2 (PEDESTRIAN ON SLAB) PROMENADE PLANK BY UNILOCK PATTERN: RUNNING BOND SIZE: 60CM X 20CM X 10CM COLOUR: TBC
 - EXPOSED AGGREGATE PAVING
 - CONCRETE PAVING LIGHT BROOM FINISH EXPANSION JOINT - 600mm O/C SAW CUT - 150mm O/C HEAVY DUTY CONCRETE PAVING LIGHT BROOM FINISH EXPANSION JOINT - 600mm O/C SAW CUT - 150mm O/C
 - CONCRETE PAVING BY BROOKLINE SIZE: 600X600X40MM
 - ASPHALT
 - SOD
- FURNISHINGS**
- BENCH
- LIGHTING**
- A POLE MOUNTED LIGHT
 - B BOLLARD LIGHT
 - Ba BOLLARD LIGHT
 - C WALL MOUNTED LIGHT
 - E STRIP LED LIGHT
 - F COLUMN LIGHT
- DETAIL KEY**
- X DETAIL NO.
 - X-X SHEET NO.

GENERAL NOTE:


- FOR ALL SITE GRADING REFER TO CIVIL DRAWINGS
- FOR ALL LIGHTING REFER TO INTEGRAL DRAWINGS

No.	Description	Date
3	Issued for SPA 2 Submission	May 06/22
2	Issued for SPA 1 Submission	Nov 19/21
1	Issued for Schematic Design	June 18/21

Revision

No.	Description	Date

City Approval Stamp

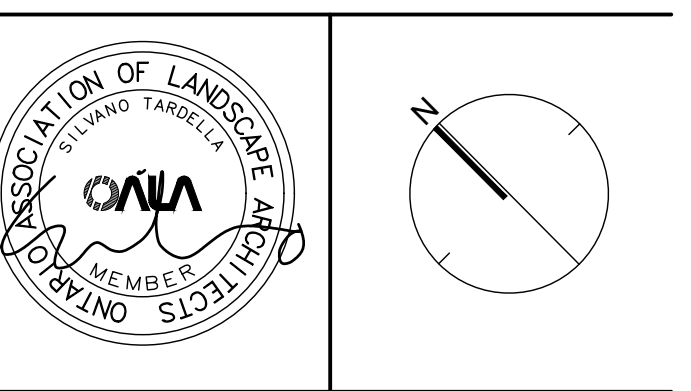


NAK design strategies

421 RONCEVALLES AVENUE, TORONTO, ON M4B 2N1 CANADA
 416.340.8700 F 416.340.7100 NAKDESIGNSTRATEGIES.COM

Oakville - Phase 4C
 Oakville, ON

Title: **SURFACE TREATMENT GENERAL PLAN**

Date: June 07 2021	Sheet:
Scale: 1:150	L1.0
Drawn: tfg	
Checked: pd	
Job No: 21148	

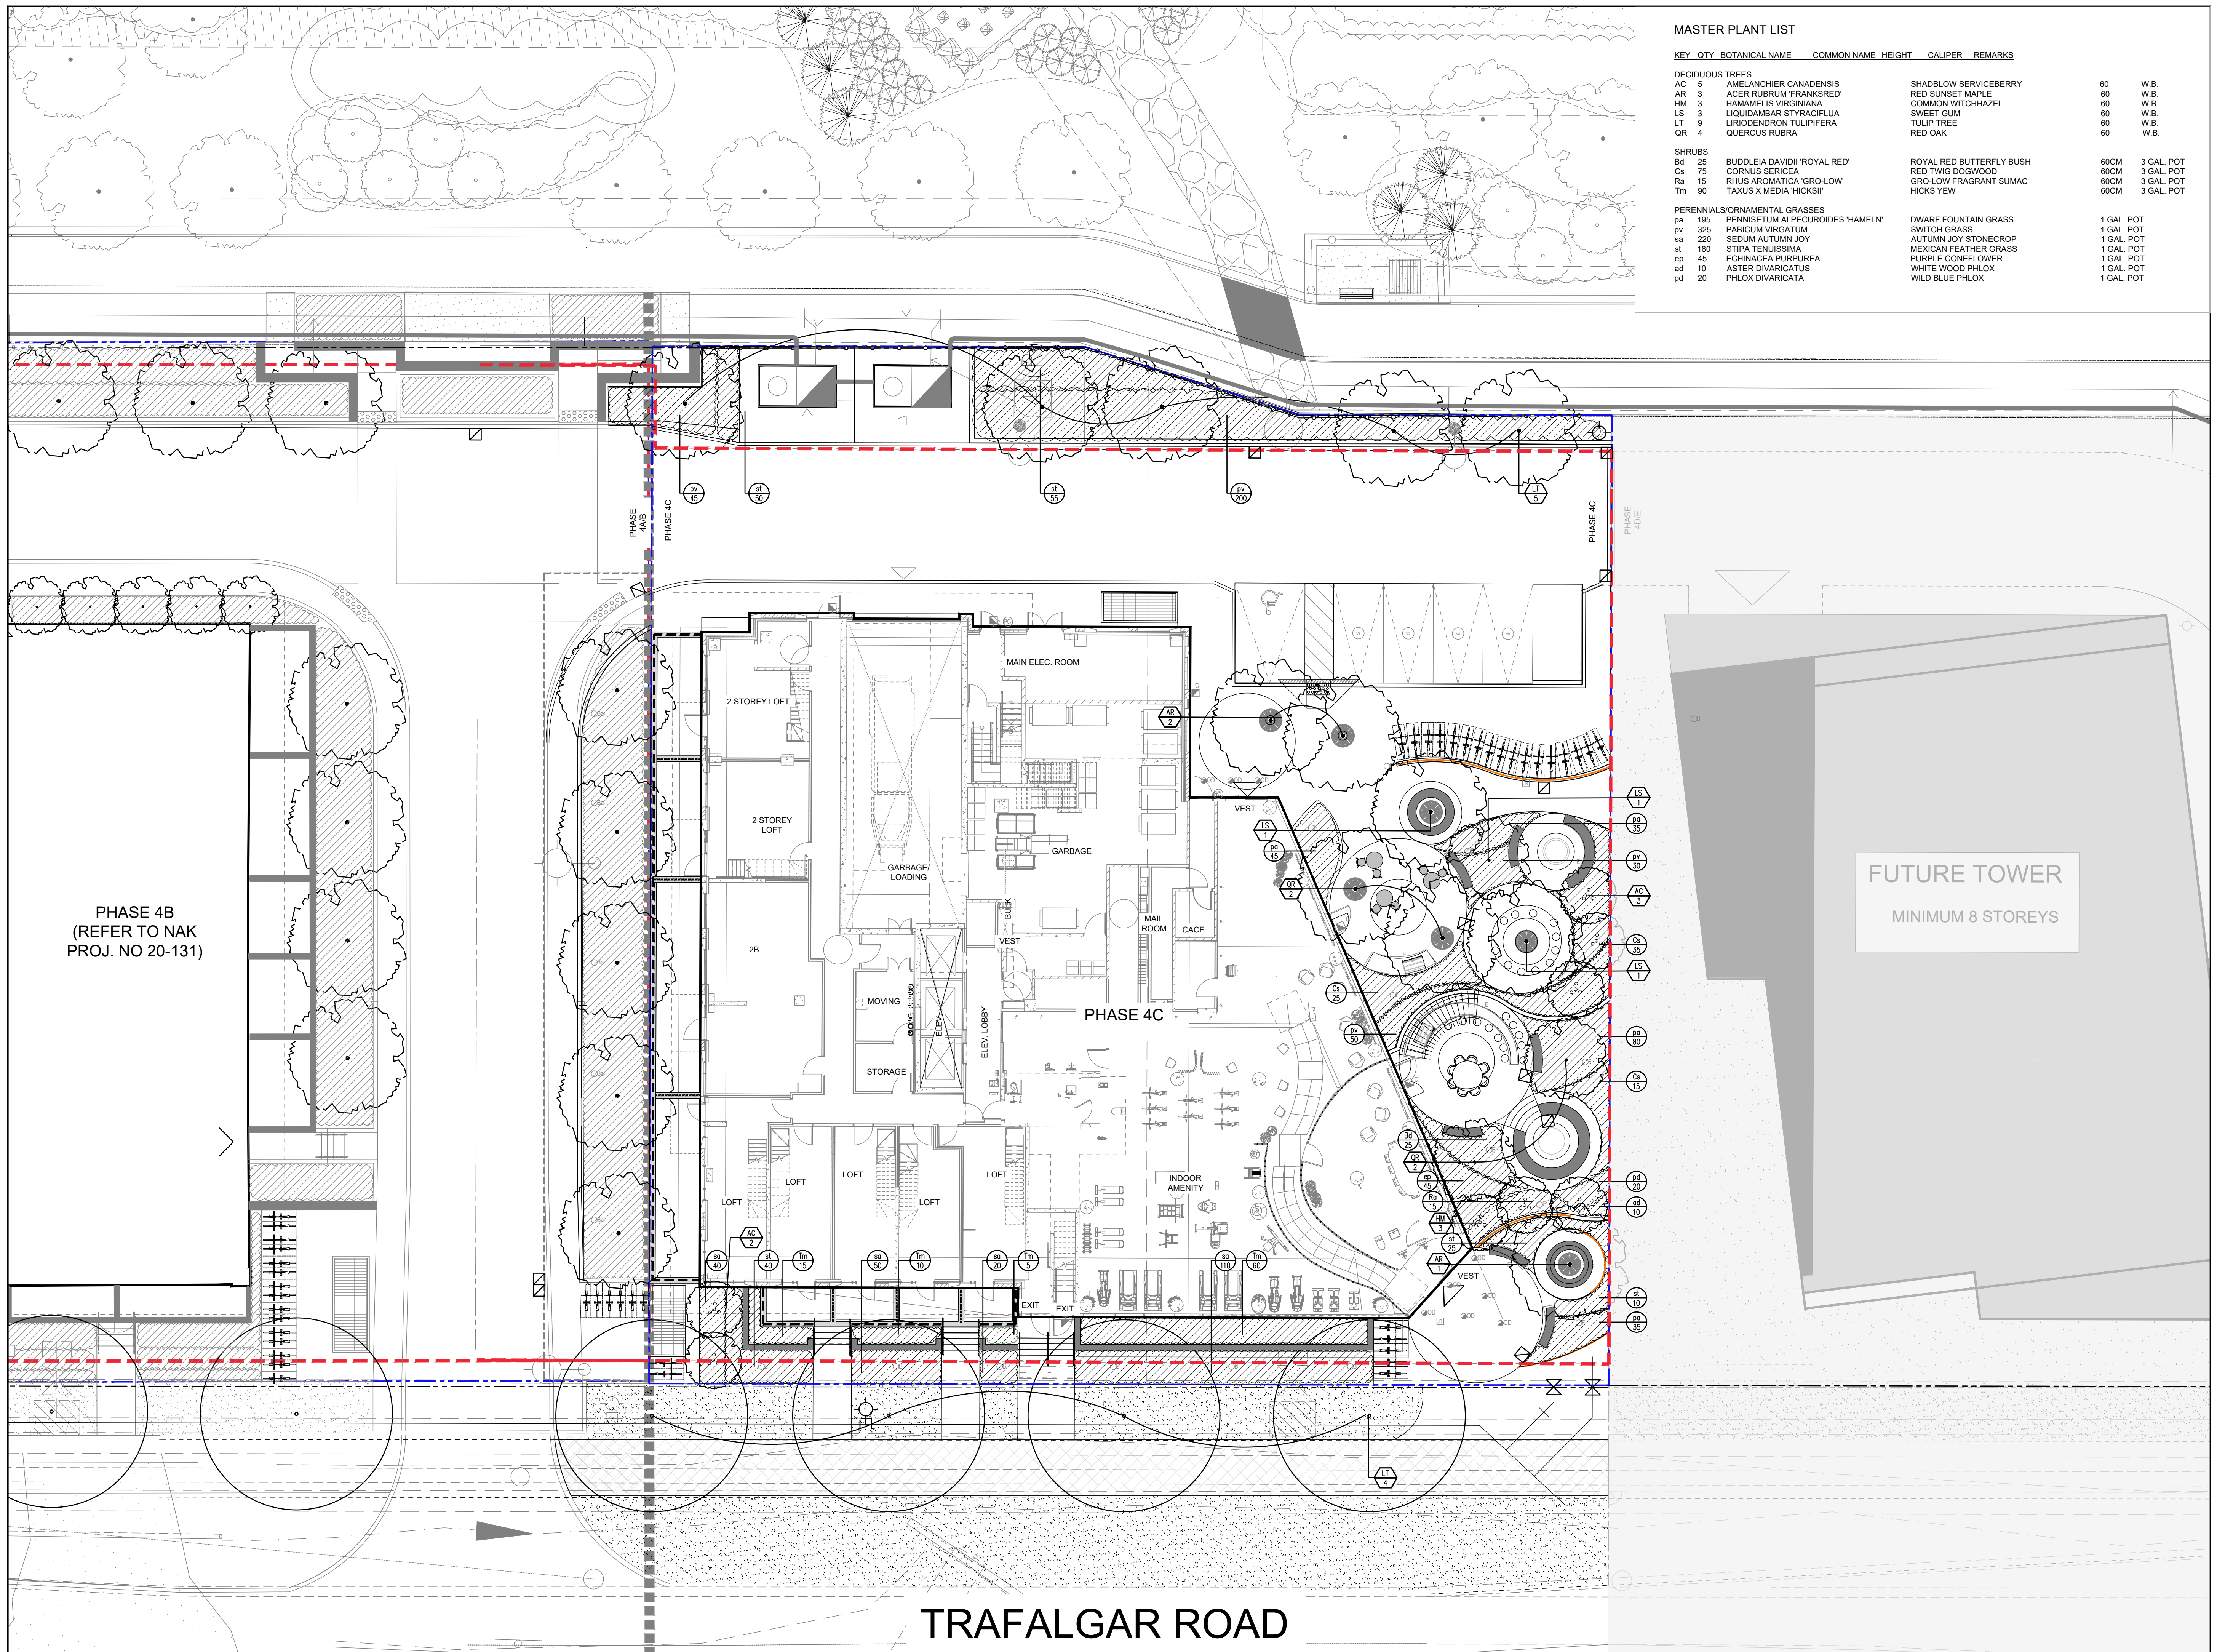

MASTER PLANT LIST

KEY	QTY	BOTANICAL NAME	COMMON NAME	HEIGHT	CALIPER	REMARKS
DECIDUOUS TREES						
AC	5	AMELANCHIER CANADENSIS	SHADBLOW SERVICEBERRY	60		W.B.
AR	3	ACER RUBRUM 'FRANKSRED'	RED SUNSET MAPLE	60		W.B.
HM	3	HAMAMELIS VIRGINIANA	COMMON WITCHHAZEL	60		W.B.
LS	3	LIQUIDAMBAR STYRACIFLUA	SWEET GUM	60		W.B.
LT	9	LIROIDENDRON TULIPIFERA	TULIP TREE	60		W.B.
QR	4	QUERCUS RUBRA	RED OAK	60		W.B.
SHRUBS						
Bd	25	BUDDLEIA DAVIDI 'ROYAL RED'	ROYAL RED BUTTERFLY BUSH	60CM	3 GAL. POT	
Cs	75	CORNUS SERICEA	RED TWIG DOGWOOD	60CM	3 GAL. POT	
Ra	15	RHUS AROMATICA 'GRO-LOW'	GRO-LOW FRAGRANT SUMAC	60CM	3 GAL. POT	
Tm	90	TAXUS X MEDIA 'HICKSII'	HICKS YEW	60CM	3 GAL. POT	
PERENNIALS/ORNAMENTAL GRASSES						
pa	195	PENNISETUM ALPECUROIDES 'HAMELN'	DWARF FOUNTAIN GRASS	1 GAL. POT		
pv	325	PABICUM VIRGATUM	SWITCH GRASS	1 GAL. POT		
sa	220	SEDUM AUTUMN JOY	AUTUMN JOY STONECROP	1 GAL. POT		
st	180	STIPA TENUISSIMA	MEXICAN FEATHER GRASS	1 GAL. POT		
ep	45	ECHINACEA PURPUREA	PURPLE CONEFLOWER	1 GAL. POT		
sd	10	ASTER DIVARICATUS	WHITE WOOD PHLOX	1 GAL. POT		
pd	20	PHLOX DIVARICATA	WILD BLUE PHLOX	1 GAL. POT		

Contractor shall check all dimensions on the work and report any discrepancy to the Landscape Architect before proceeding. All drawings and specifications are the property of the Landscape Architect and must be returned at the completion of the work. This drawing is not to be used for construction until signed by the Landscape Architect.

LEGEND

- PHASE LINE
- - - PROPERTY LINE
- - - LIMIT OF STRUCTURAL SLAB
- - - 1.2m DECORATIVE METAL FENCE
- - - 1.2m PRIVACY RAILING
- - - 1.8m PATIO DIVIDERS
- - - HANDRAILS

PLANTING

- MULTI-STEM TREE
- DECIDUOUS TREE
- CONIFEROUS TREE
- SHRUBS
- LIMIT OF BED

SURFACING

- ▨ SOD

DETAIL KEY

- X DETAIL NO.
- X-Y SHEET NO.

PLANTING KEY

- XX/00 TREE SPECIES QUANTITY
- XX/00 SHRUB SPECIES QUANTITY

PHASE 4B
(REFER TO NAK
PROJ. NO 20-131)

FUTURE TOWER
MINIMUM 8 STOREYS

No.	Description	Date
3	Issued for SPA 2 Submission	May 06/22
2	Issued for SPA 1 Submission	Nov 19/21
1	Issued for Schematic Design	June 18/21
	Revision	

City Approval Stamp

NAK
design strategies

421 RONCEVALLES AVENUE, TORONTO, ON M4R 2N1 CANADA
T 416.340.8700 F 416.340.7100 NAKDESIGNSTRATEGIES.COM

Oakville - Phase 4C
Oakville, ON

Title
PLANTING PLAN

Date	June 07 2021	Sheet	
Scale	1:150		
Drawn	tf		
Checked	pd		
Job No.	21148		L1.1

TRAFALGAR ROAD

STORMWATER MANAGEMENT POND (REFER TO NAK PROJ. NO 14-055)

REFER TO L1.0 SURFACE TREATMENT GENERAL PLAN

PHASE 4B (REFER TO NAK PROJ. NO 20-131)

FUTURE TOWER MINIMUM 8 STOREYS

TRAFALGAR ROAD

Contractor shall check all dimensions on the work and report any discrepancy to the Landscape Architect before proceeding. All drawings and specifications are the property of the Landscape Architect and must be returned at the completion of the work. This drawing is not to be used for construction until signed by the Landscape Architect.

- LEGEND**
- PHASE LINE
 - PROPERTY LINE
 - LIMIT OF STRUCTURAL SLAB
 - 1.2m DECORATIVE METAL FENCE
 - 1.2m PRIVACY RAILING
 - 1.8m PATIO DIVIDERS
 - HANDRAILS

- SURFACING**
- UNIT PAVING (VEHICULAR ON SLAB) PROMENADE PLANK BY UNILOCK PATTERN: HERRINGBONE SIZE: 60CM X 20CM X 10CM COLOUR: GRANITE BLEND IL CAMPO
 - UNIT PAVING TYPE 1 (PEDESTRIAN ON SLAB) PROMENADE PLANK BY UNILOCK PATTERN: RUNNING BOND SIZE: 60CM X 20CM X 10CM COLOUR: OPAL
 - UNIT PAVING TYPE 2 (PEDESTRIAN ON SLAB) PROMENADE PLANK BY UNILOCK PATTERN: RUNNING BOND SIZE: 60CM X 20CM X 10CM COLOUR: TBC
 - EXPOSED AGGREGATE PAVING
 - CONCRETE PAVING LIGHT BROOM FINISH EXPANSION JOINT - 600mm O/C SAW CUT - 150mm O/C HEAVY DUTY CONCRETE PAVING LIGHT BROOM FINISH EXPANSION JOINT - 600mm O/C SAW CUT - 150mm O/C
 - CONCRETE PAVING BY BROOKLINE SIZE: 600X600X40MM
 - ASPHALT
 - SOD

- FURNISHINGS**
- BENCH
- LIGHTING**
- A POLE MOUNTED LIGHT
 - B BOLLARD LIGHT
 - Ba BOLLARD LIGHT
 - C WALL MOUNTED LIGHT
 - E STRIP LED LIGHT
 - F COLUMN LIGHT


- DETAIL KEY**
- X DETAIL NO.
 - X-X SHEET NO.

- GENERAL NOTE:**
- FOR ALL SITE GRADING REFER TO CIVIL DRAWINGS
 - FOR ALL LIGHTING REFER TO INTEGRAL DRAWINGS
 - PROPOSED CONCRETE PAVED WALKWAYS LINKING THE PEDESTRIAN ENTRY WAYS FROM THE BUILDING TO THE REGIONS MULTITUSE TRAIL WILL BE INSTALLED AFTER THE MUD IS COMPLETED BY THE REGION. PLEASE REFER TO ULTIMATE DRAWING L1.

No.	Description	Date
3	Issued for SPA 2 Submission	May 06/22
2	Issued for SPA 1 Submission	Nov 19/21
1	Issued for Schematic Design	June 18/21

Revision

City Approval Stamp

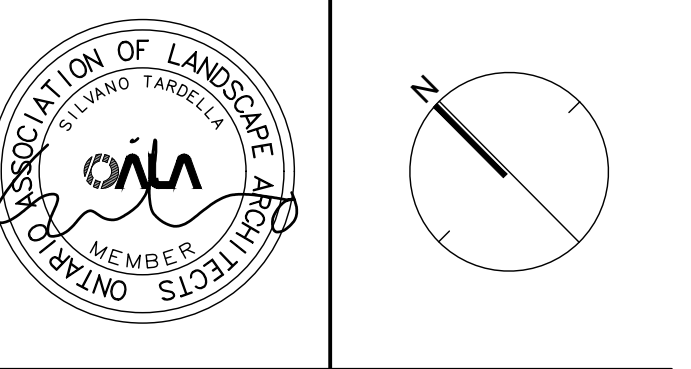

NAK
design strategies

421 RONCEVALLES AVENUE, TORONTO, ON M4R 2N1 CANADA
T 416.340.8700 F 416.340.7100 NAKDESIGNSTRATEGIES.COM


Project

Oakville - Phase 4C
Oakville, ON

Title
INTERIM STREETSCAPE PLAN TRAFALGAR ROAD

Date	June 07 2021	Sheet	
Scale	1:150		
Drawn	tf		
Checked	pd		
Job No.	21148		

L1.3

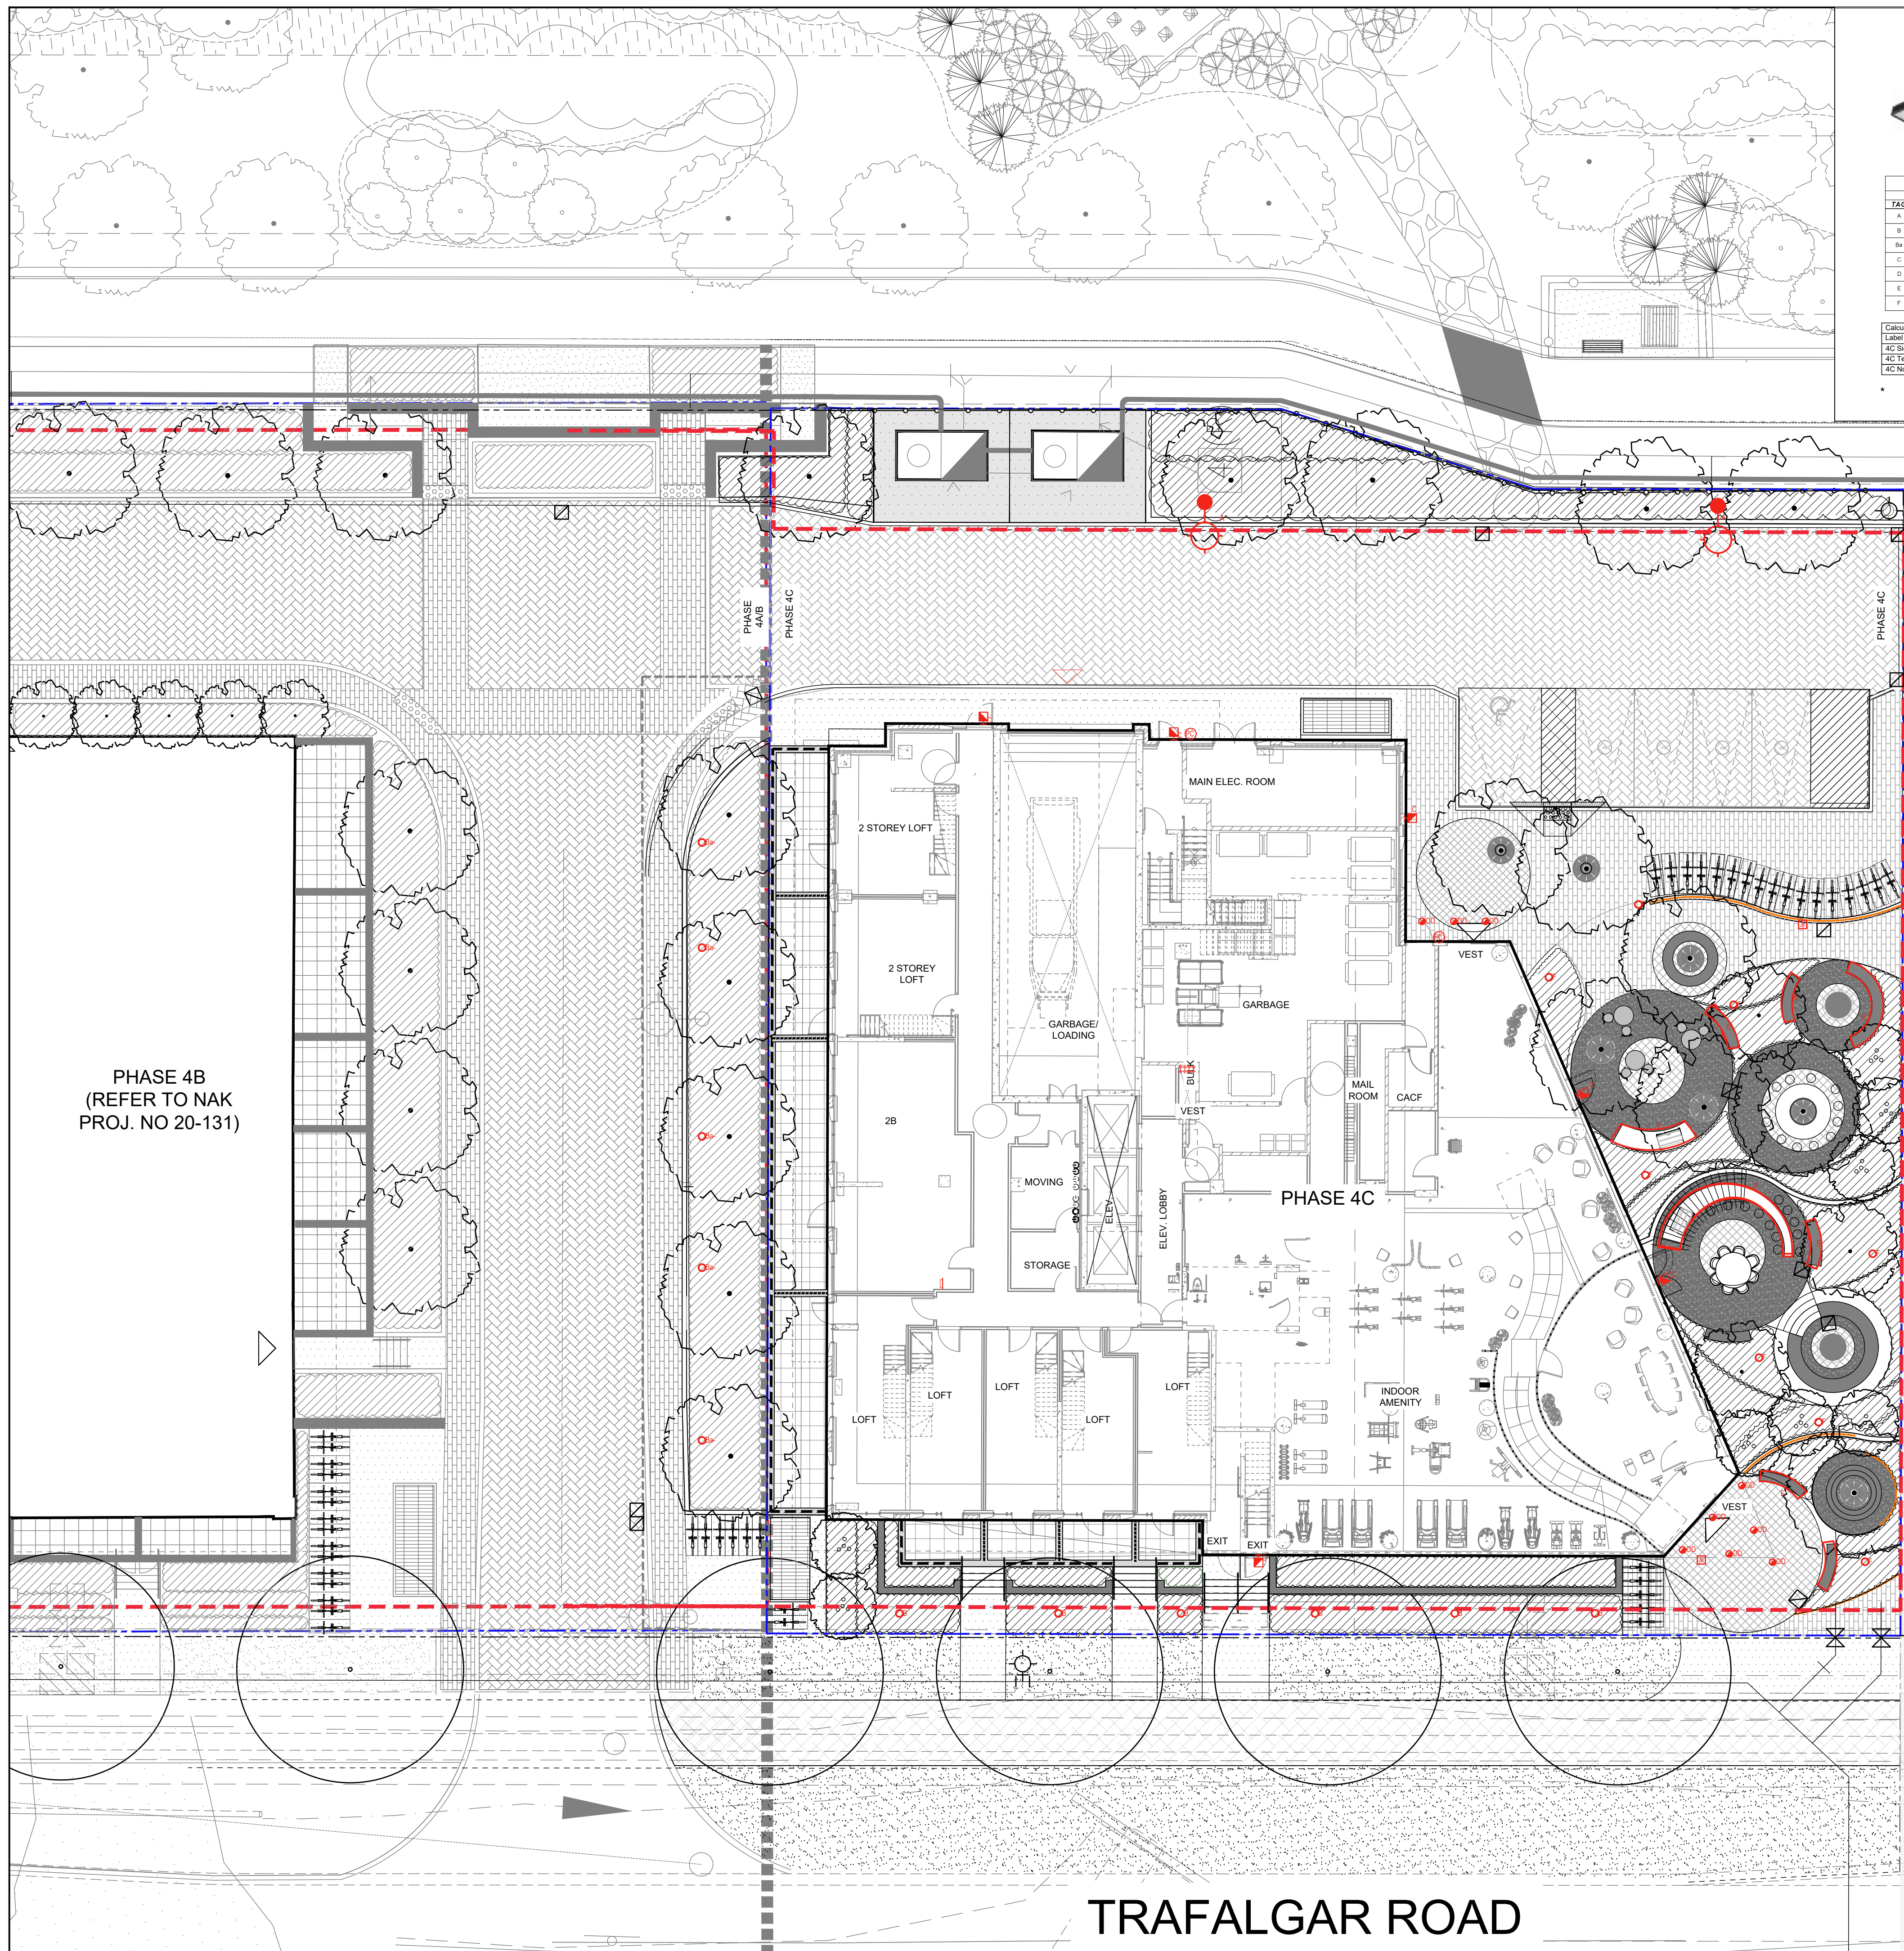

LUMINAIRE SCHEDULE										
TAD	DESCRIPTION	EQUIPMENT INFO.	LOCATION	MODEL	POWER	VOL. TAG	LAMP	ALUMINANCE	CCCT (K)	CRF
A	1/2 WALL MOUNTED AREA LIGHT WITH T2 30° BEAM ANGLE	INDUSTRIAL LIGHTING PRODUCTS AL-65W-UH-12	W/12	AL-65W-UH-12	58 W	120 V	LED	4000 K	4000 K	70
B	3/2 SITE BOLLARD WITH TYPE B DISTRIBUTION	INDUSTRIAL LIGHTING PRODUCTS BOLL-15W-LED-400K	W/12	BOLL-15W-LED-400K	15 W	120 V	LED	4000 K	4000 K	70
Ba	3/2 SITE BOLLARD WITH 90 DEGREE DISTRIBUTION	INDUSTRIAL LIGHTING PRODUCTS BOLL-15W-LED-400K-90	W/12	BOLL-15W-LED-400K-90	15 W	120 V	LED	4000 K	4000 K	70
C	WALL MOUNTED PACK WITH T4 DISTRIBUTION	INDUSTRIAL LIGHTING PRODUCTS WPCS-30W-LED-400K-14	W/12	WPCS-30W-LED-400K-14	29 W	120 V	LED	4000 K	4000 K	70
D	1/2 WALL MOUNTED AREA LIGHT WITH T4 30° BEAM ANGLE	INDUSTRIAL LIGHTING PRODUCTS AL-65W-UH-14	W/12	AL-65W-UH-14	58 W	120 V	LED	4000 K	4000 K	70
E	STRIP LIGHT	PHILIPS HALE WHITE LIGHTSTRIP PLUS	W/12	PHILIPS HALE WHITE LIGHTSTRIP PLUS	3.65 W / F	120 V	LED	4000 K	4000 K	70
F	1/2 COLUMN LIGHT WITH SYMMETRIC DISTRIBUTION	BEGA 84 901	W/12	BEGA 84 901	54 W	120 V	LED	4000 K	4000 K	70

Calculation Summary						
Label	Calc Type	Units	Avg	Max	Min	Avg/Min
4C Schematic Trafalgar	Illuminance	Lux	33.52	139.3	1.8	17.44
4C Terrace - East	Illuminance	Lux	30.43	150.8	8.3	3.67
4C North Road	Illuminance	Lux	25.65	114.8	6.7	3.83

ALL LIGHTING DEVICES SHALL BE FULL CUT OFF AND NIGHT SKY FRIENDLY, AND SHALL BE MITIGATED AT THE SOURCE SO THAT NO LIGHT (0.0 fc) WILL BE DIRECTLY PROJECTED ONTO ADJACENT PROPERTIES

Contractor shall check all dimensions on the work and report any discrepancy to the Landscape Architect before proceeding. All drawings and specifications are the property of the Landscape Architect and must be returned at the completion of the work. This drawing is not to be used for construction until signed by the Landscape Architect.

LEGEND

- PHASE LINE
- PROPERTY LINE
- LIMIT OF STRUCTURAL SLAB
- 1.2m DECORATIVE METAL FENCE
- 1.2m PRIVACY RAILING
- 1.8m PATIO DIVIDERS
- HANDRAILS

SURFACING

- UNIT PAVING (VEHICULAR ON SLAB) PROMENADE PLANK BY UNILOCK PATTERN: HERRINGBONE SIZE: 60CM X 20CM X 10CM COLOUR: GRANITE BLEND IL CAMPO
- UNIT PAVING TYPE 1 (PEDESTRIAN ON SLAB) PROMENADE PLANK BY UNILOCK PATTERN: RUNNING BOND SIZE: 60CM X 20CM X 10CM COLOUR: OPAL
- UNIT PAVING TYPE 2 (PEDESTRIAN ON SLAB) PROMENADE PLANK BY UNILOCK PATTERN: RUNNING BOND SIZE: 60CM X 20CM X 10CM COLOUR: TBC
- EXPOSED AGGREGATE PAVING
- CONCRETE PAVING LIGHT BROOM FINISH EXPANSION JOINT - 600mm O/C SAW CUT - 1500mm O/C HEAVY DUTY CONCRETE PAVING LIGHT BROOM FINISH EXPANSION JOINT - 600mm O/C SAW CUT - 1500mm O/C
- CONCRETE PAVING BY BROOKLINE SIZE: 600X600X40MM
- ASPHALT
- SOD

FURNISHINGS

- BENCH

LIGHTING

- A POLE MOUNTED LIGHT
- B BOLLARD LIGHT
- Ba BOLLARD LIGHT
- C WALL MOUNTED LIGHT
- D STRIP LED LIGHT
- E COLUMN LIGHT

DETAIL KEY

- X DETAIL NO.
- X-X SHEET NO.


GENERAL NOTE:

- FOR ALL SITE GRADING REFER TO CIVIL DRAWINGS
- FOR ALL LIGHTING REFER TO INTEGRAL DRAWINGS

No.	Description	Date
3	Issued for SPA 2 Submission	May 06/22
2	Issued for SPA 1 Submission	Nov 19/21
1	Issued for Schematic Design	June 18/21

Revision

City Approval Stamp

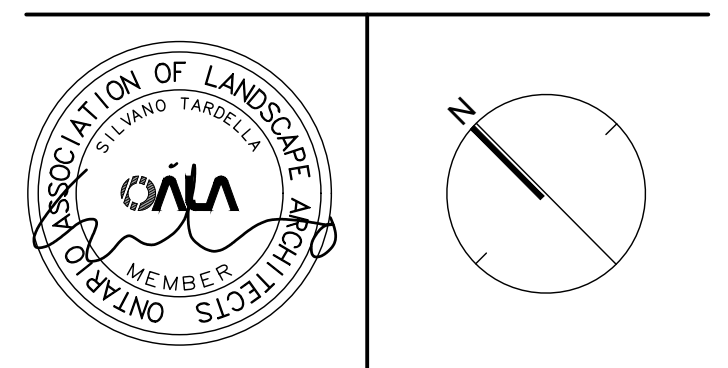

NAK
design strategies

421 RONCEVALLES AVENUE, TORONTO, ON M4B 2N1 CANADA
T 416.340.8700 F 416.340.7100 NAKDESIGNSTRATEGIES.COM

Oakville - Phase 4C
Oakville, ON

Title
LIGHTING PLAN

Date	June 07 2021	Sheet	
Scale	1:150		
Drawn	tfj		
Checked	pd		
Job No.	21148		

L1.4