



PRECAST PAVING WALKWAY (W/ CONCRETE SUB-BASE) X-SECTION N.T.S.

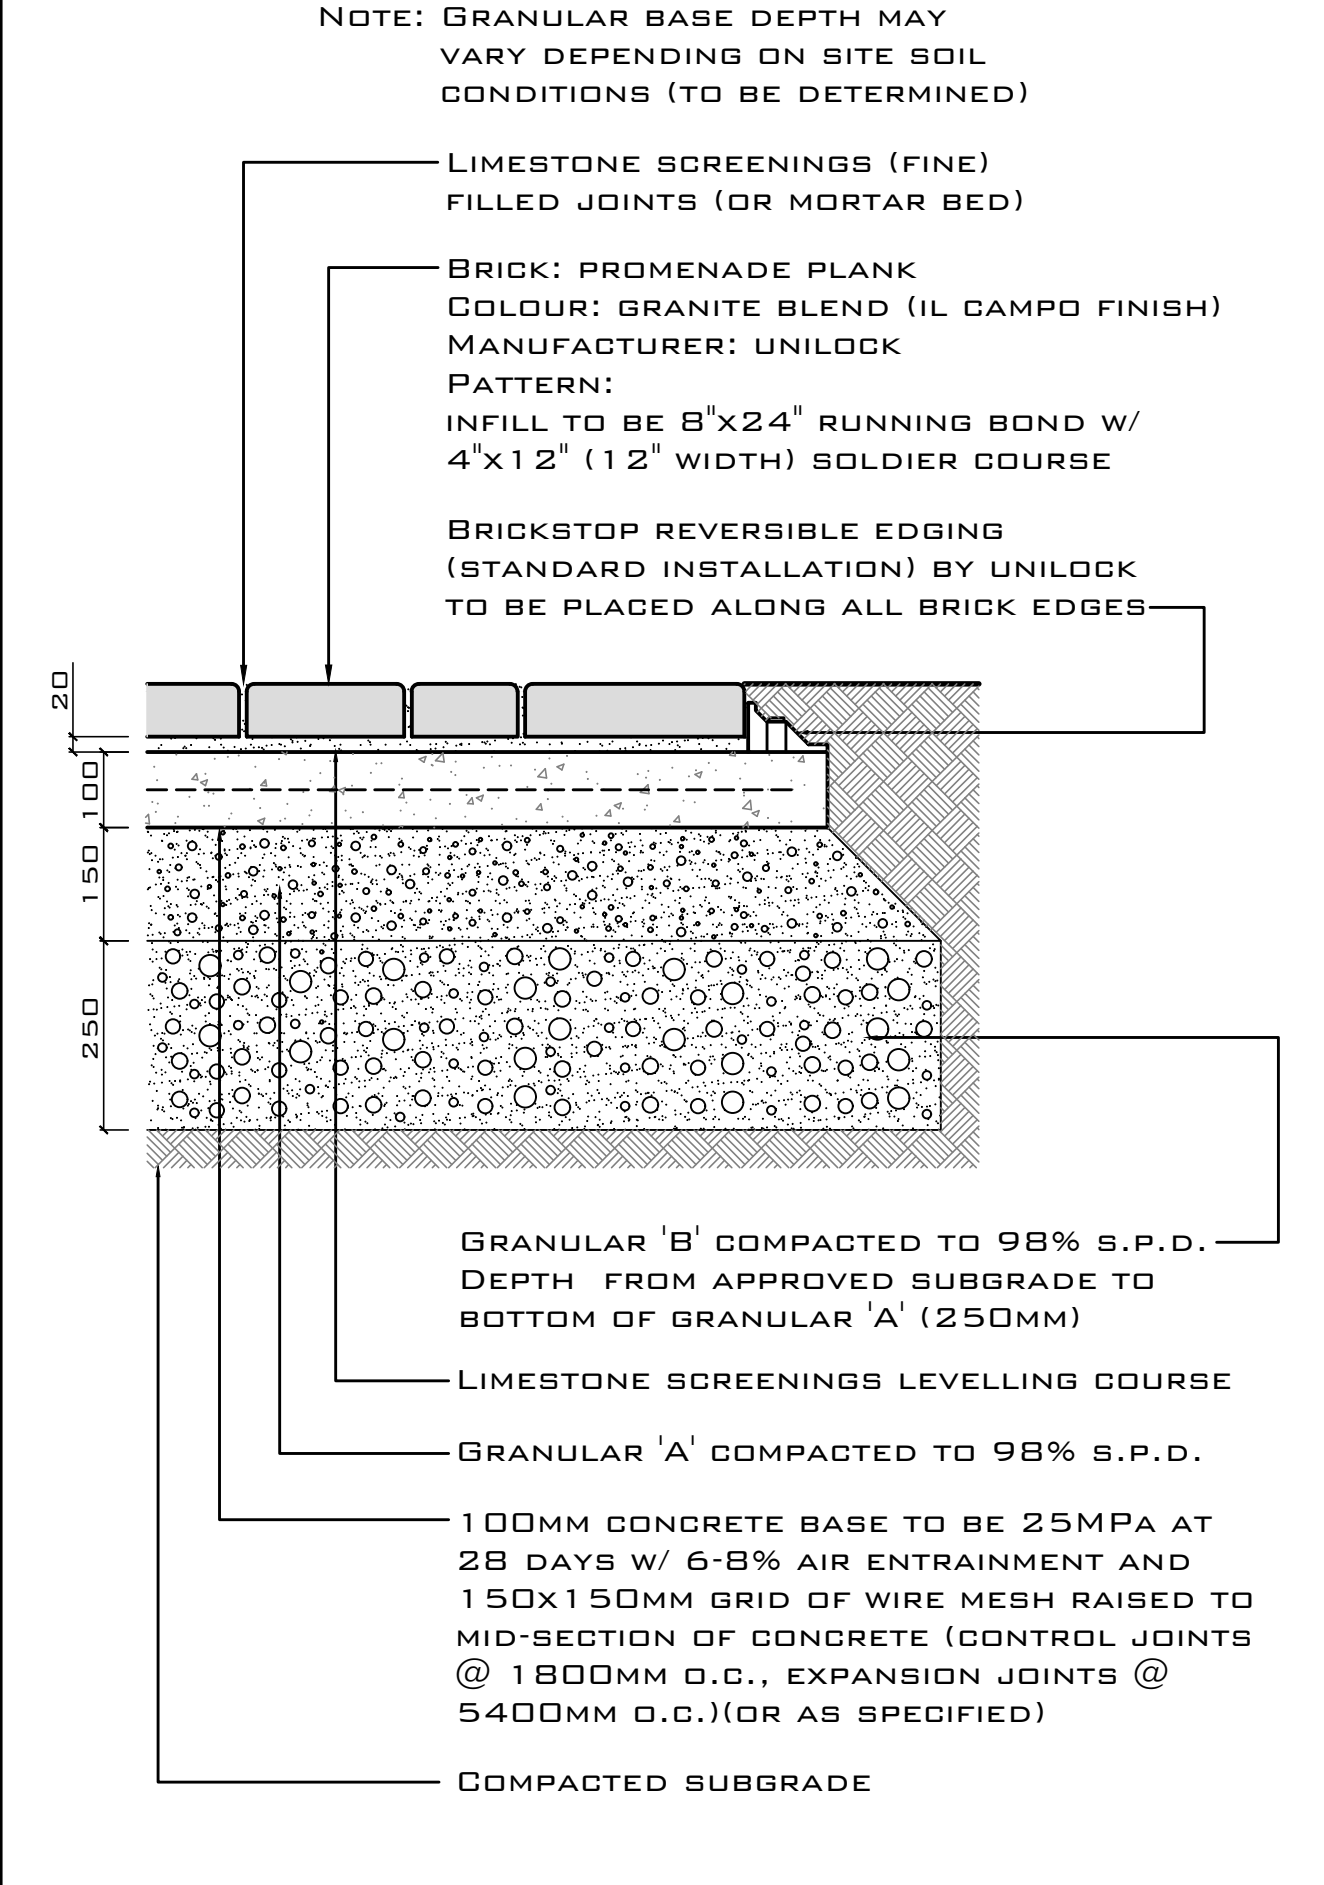

PERMEABLE PRECAST WALKWAY X-SECTION N.T.S.

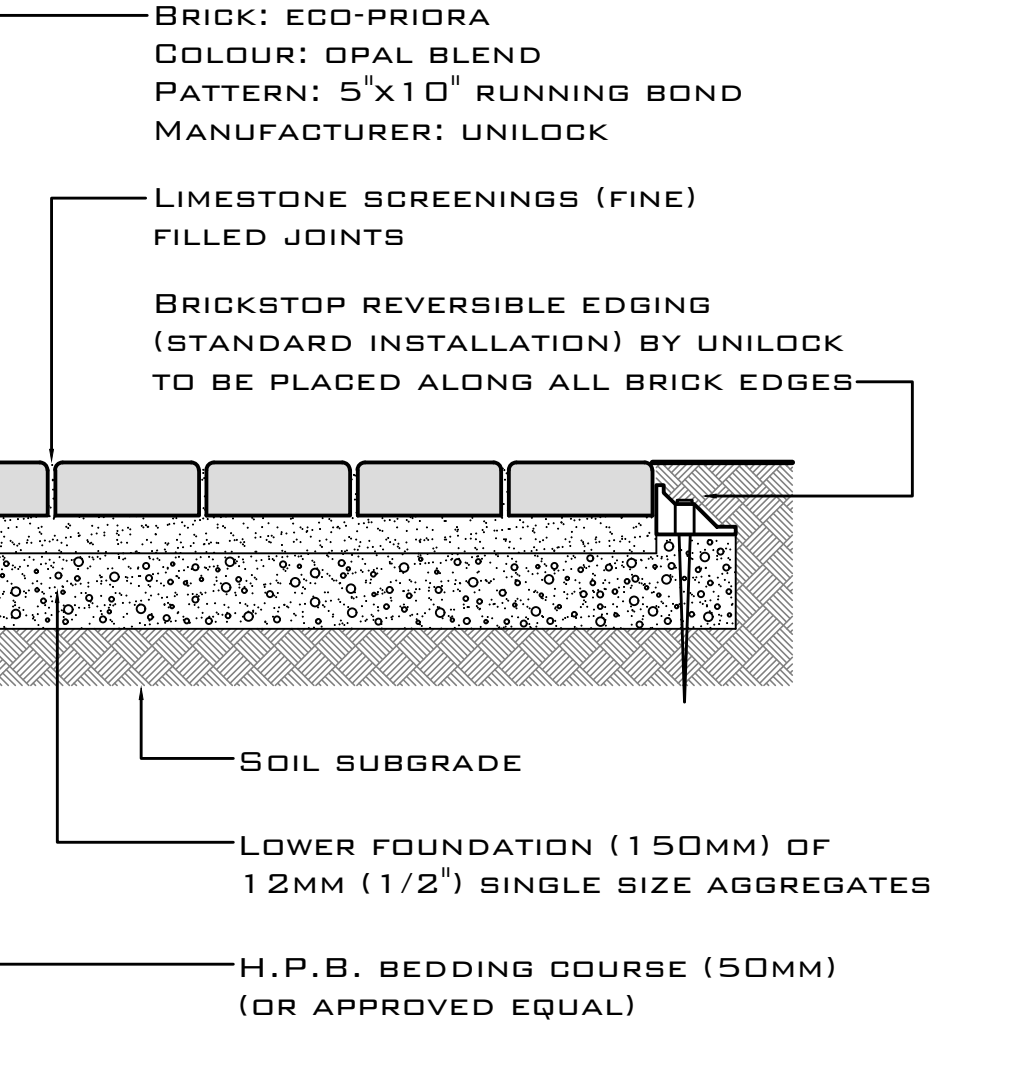

ELECTRICAL LEGEND/NOTES:



THE FOLLOWING FIXTURES TO BE AS SUPPLIED BY (OR APPROVED EQUAL):

ESTATE LIGHTING SUPPLY
190 HIGHWAY #7 WEST
UNITS #53-54
BRAMPTON, ONTARIO, L7A 1A2
(TEL) 877-874-1022

THE FOLLOWING FIXTURES TO BE AS MANUFACTURED BY (OR APPROVED EQUAL):

CAST LIGHTING LLC
(TEL) 800-914-CAST
(WEB) WWW.CAST-LIGHTING.COM

PL - GOOSENECK
#MR-16 AREA/PATH

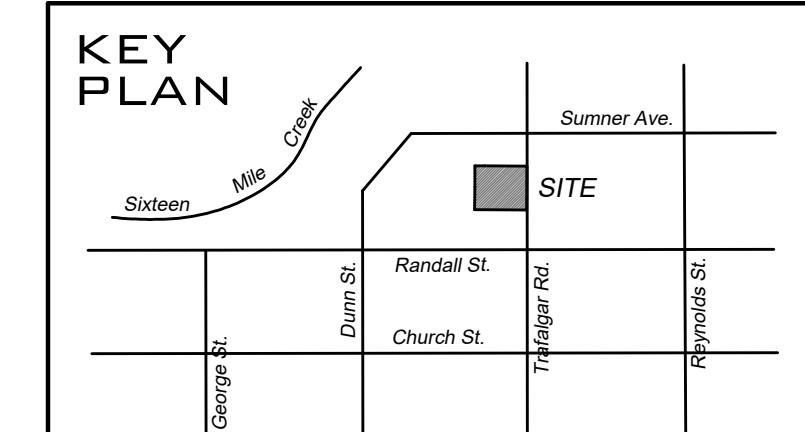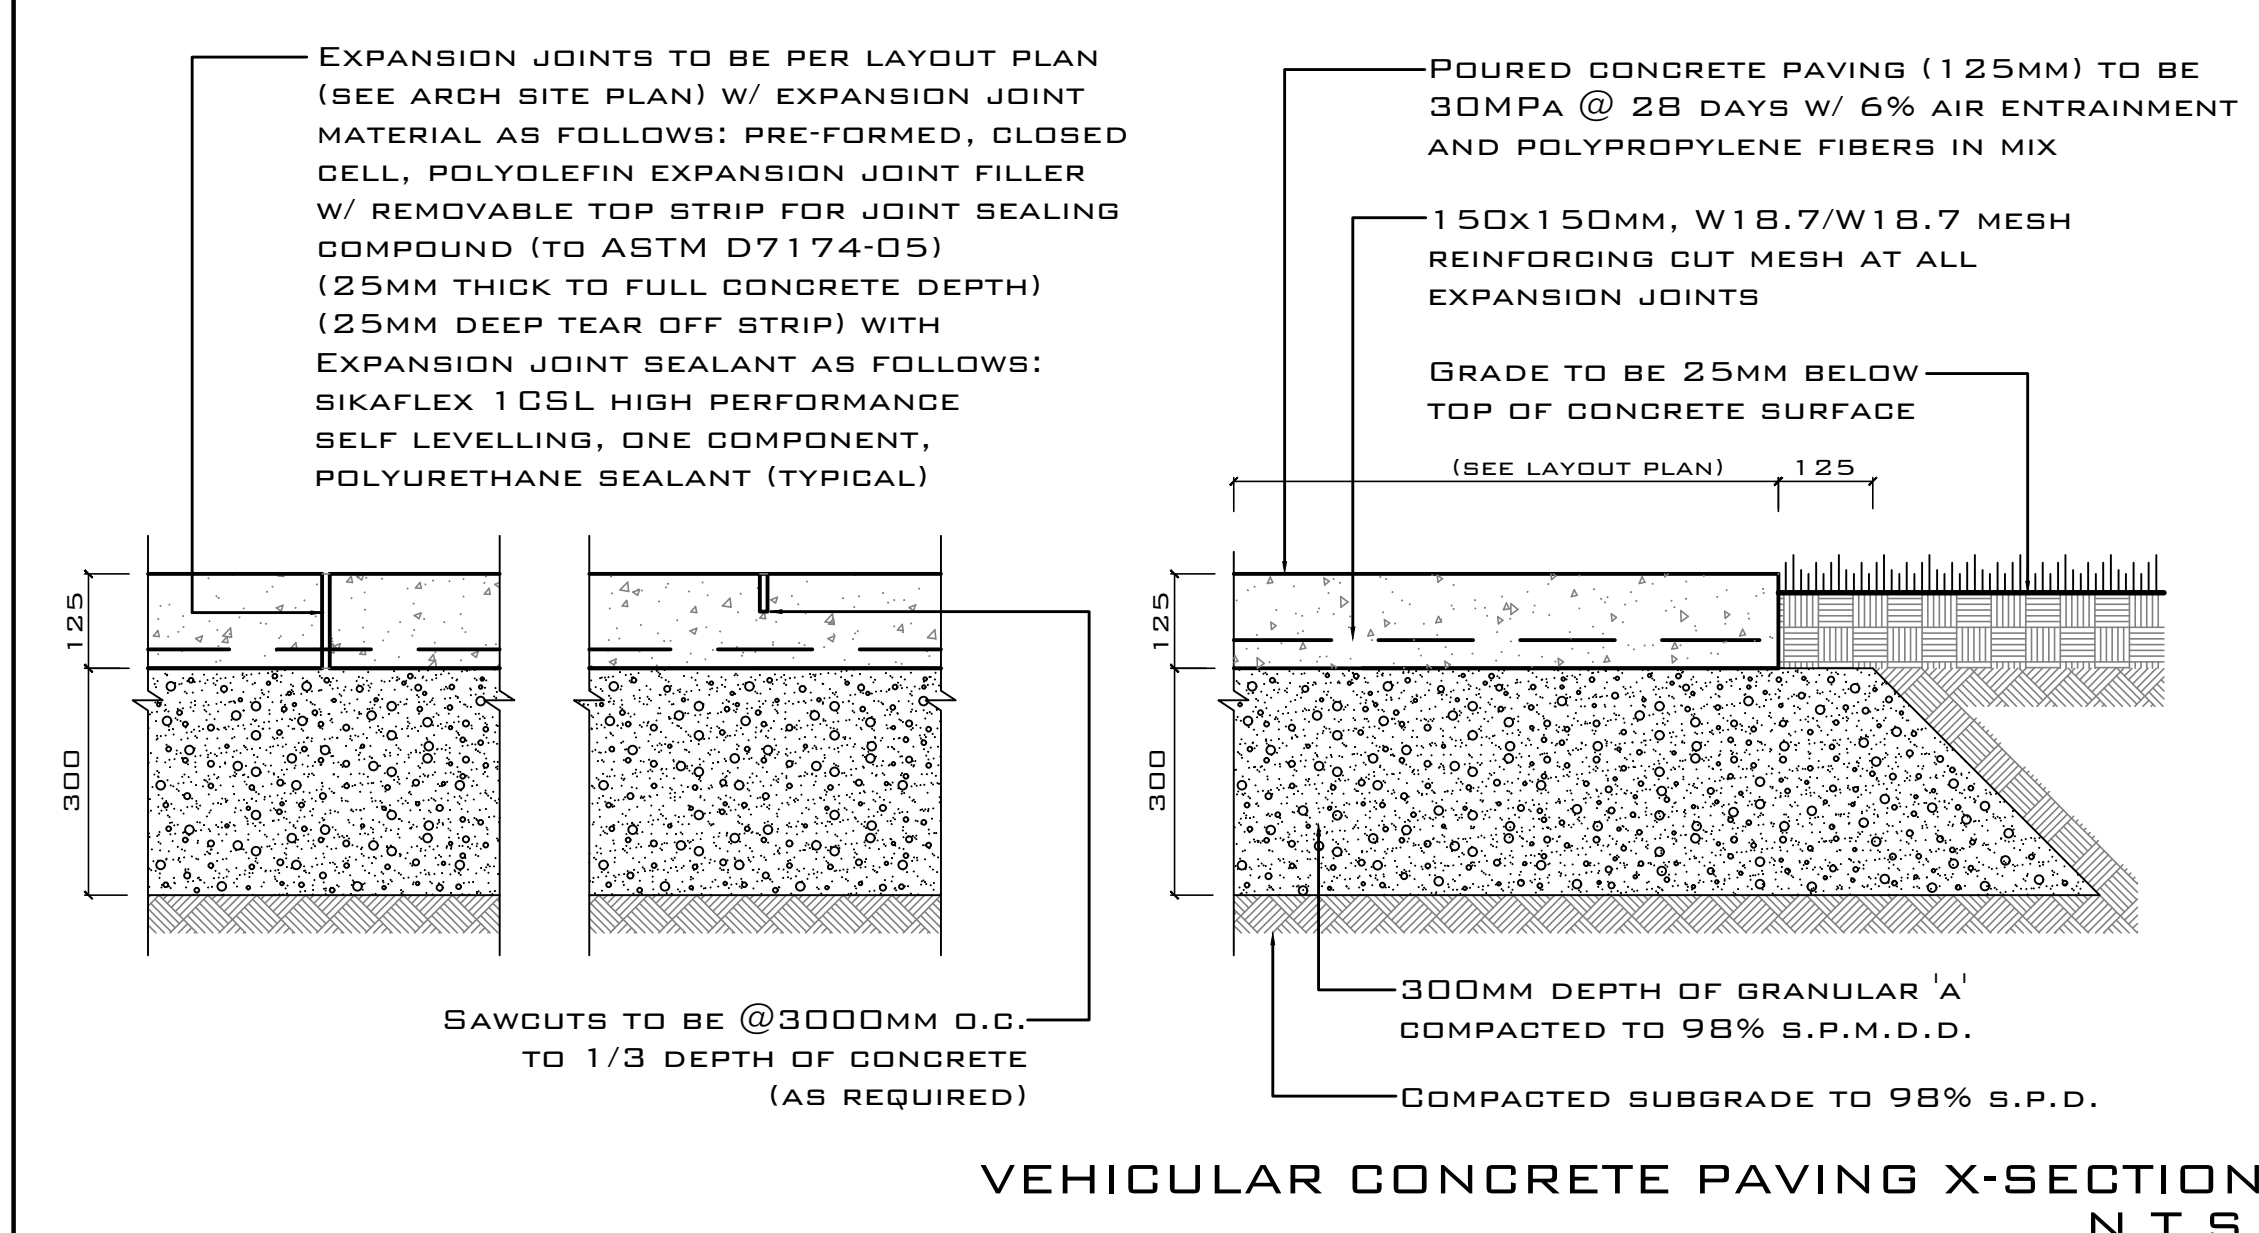


PLANTING NOTES:

ALL AREAS NOTED AS SODDED TO HAVE #1 NURSERY BROWN SOD W/ 200MM DEPTH (MINIMUM) TOPSOIL (TYPICAL)

ALL PLANTED AREAS TO HAVE 300MM DEPTH (MINIMUM) OF PLANTING MIX, AND 100MM DEPTH (MINIMUM) OF BLACK COMPOSTED BARK MULCH BY BRO-BARK LIMITED (NOTE: MULCH LEVEL TO BE 100MM ABOVE SOD LEVEL)



RIVERSTONE NOTES:

AREA NOTED AS RIVERSTONE BORDER TO HAVE 3"-5" DIAMETER RIVERSTONE WITH LANDSCAPE FILTER FABRIC (CONTINUOUS)

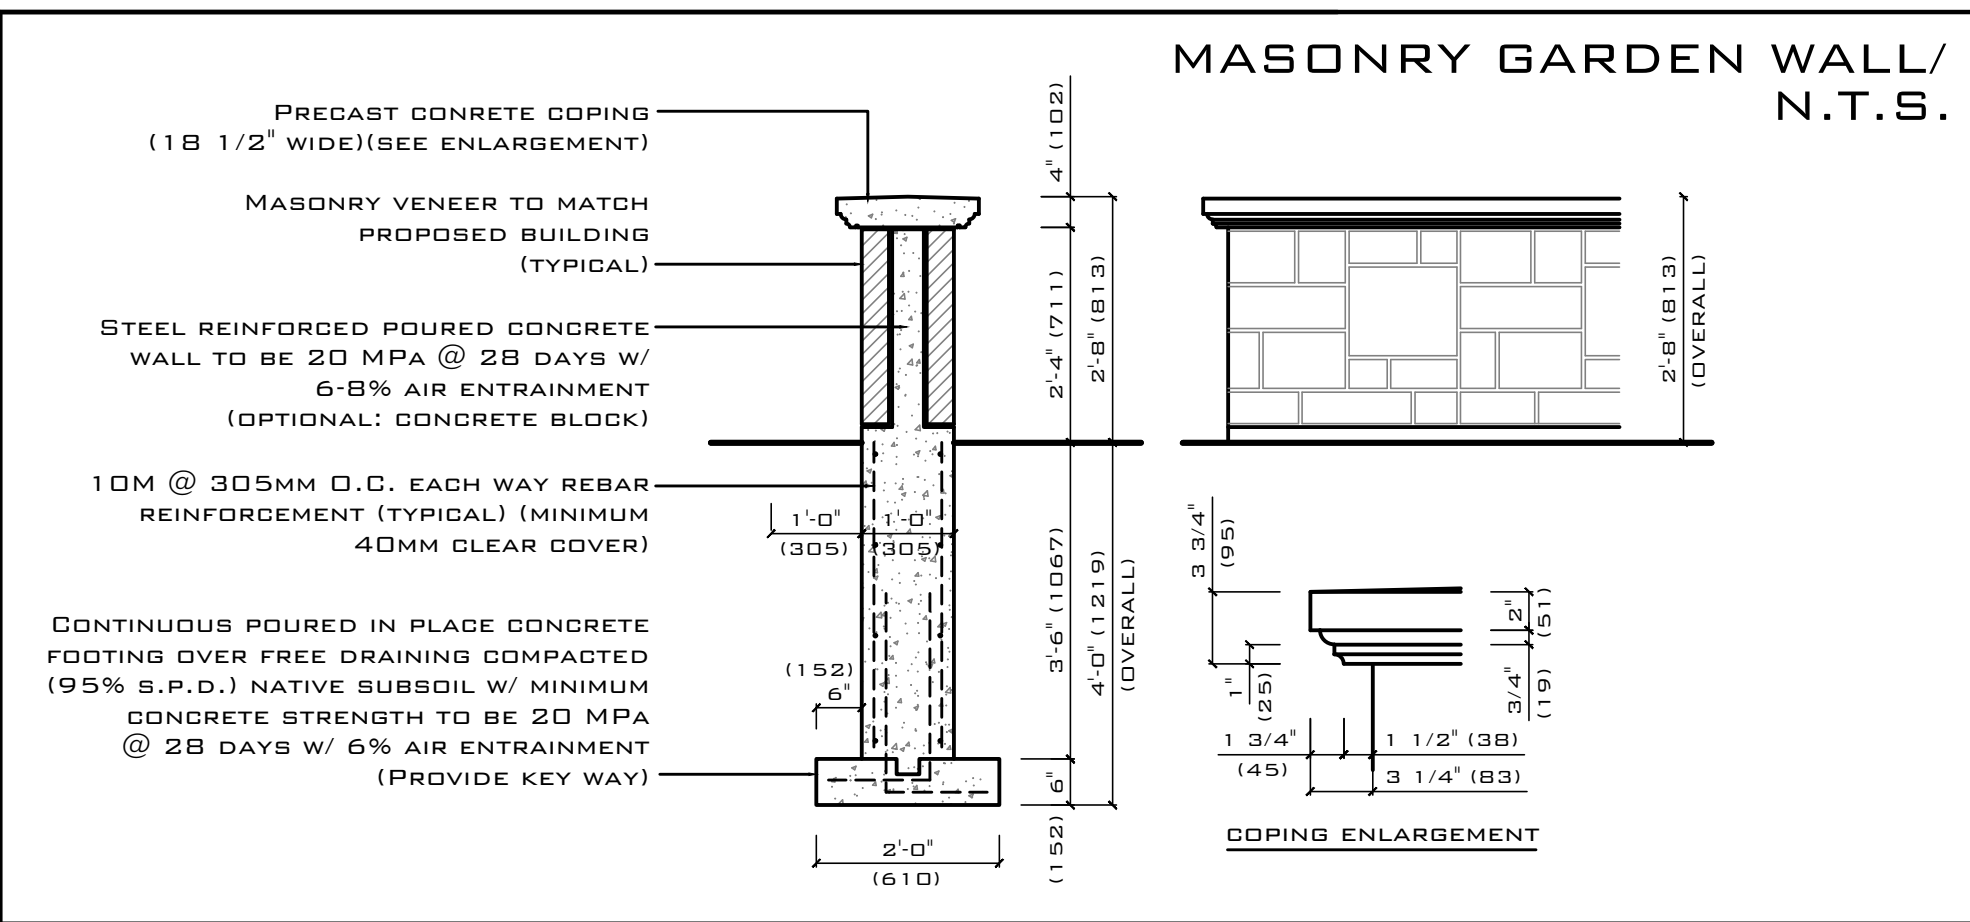

PLANT LIST

KEY	BOTANICAL NAME	COMMON NAME	NUM	SIZE	COND	REMARKS
AA	ACER PALMATUM 'BLOODGOOD'	BLOODGOOD JAPANESE MAPLE	1	30MM CAL	25 GAL	MULTI-STEMMED
AB	FAGUS SYLVATICA 'ROHANI'	ROHANI OAKLEAF COPPER BEECH	3	50MM CAL		
AC	QUERCUS ROBUR ALBA 'SKINNY GENES'	SKINNY GENES OAK	4	60MM CAL		
BA	TAXUS MEDIA 'HILLI'	HILL'S YEW	6	120MM HT		
CB	HYDRANGEA PANICULATA 'BOBO'	BOBO HYDRANGEA	18	60MM HT		
CC	HYDRANGEA SERRATA 'PINK DYNAMO'	PINK DYNAMO HYDRANGEA	4	80CM HT		
EB	IMPERATA CYLINDRICA 'RUBRA'	JAPANESE BLOOD GRASS	24	POTTED		

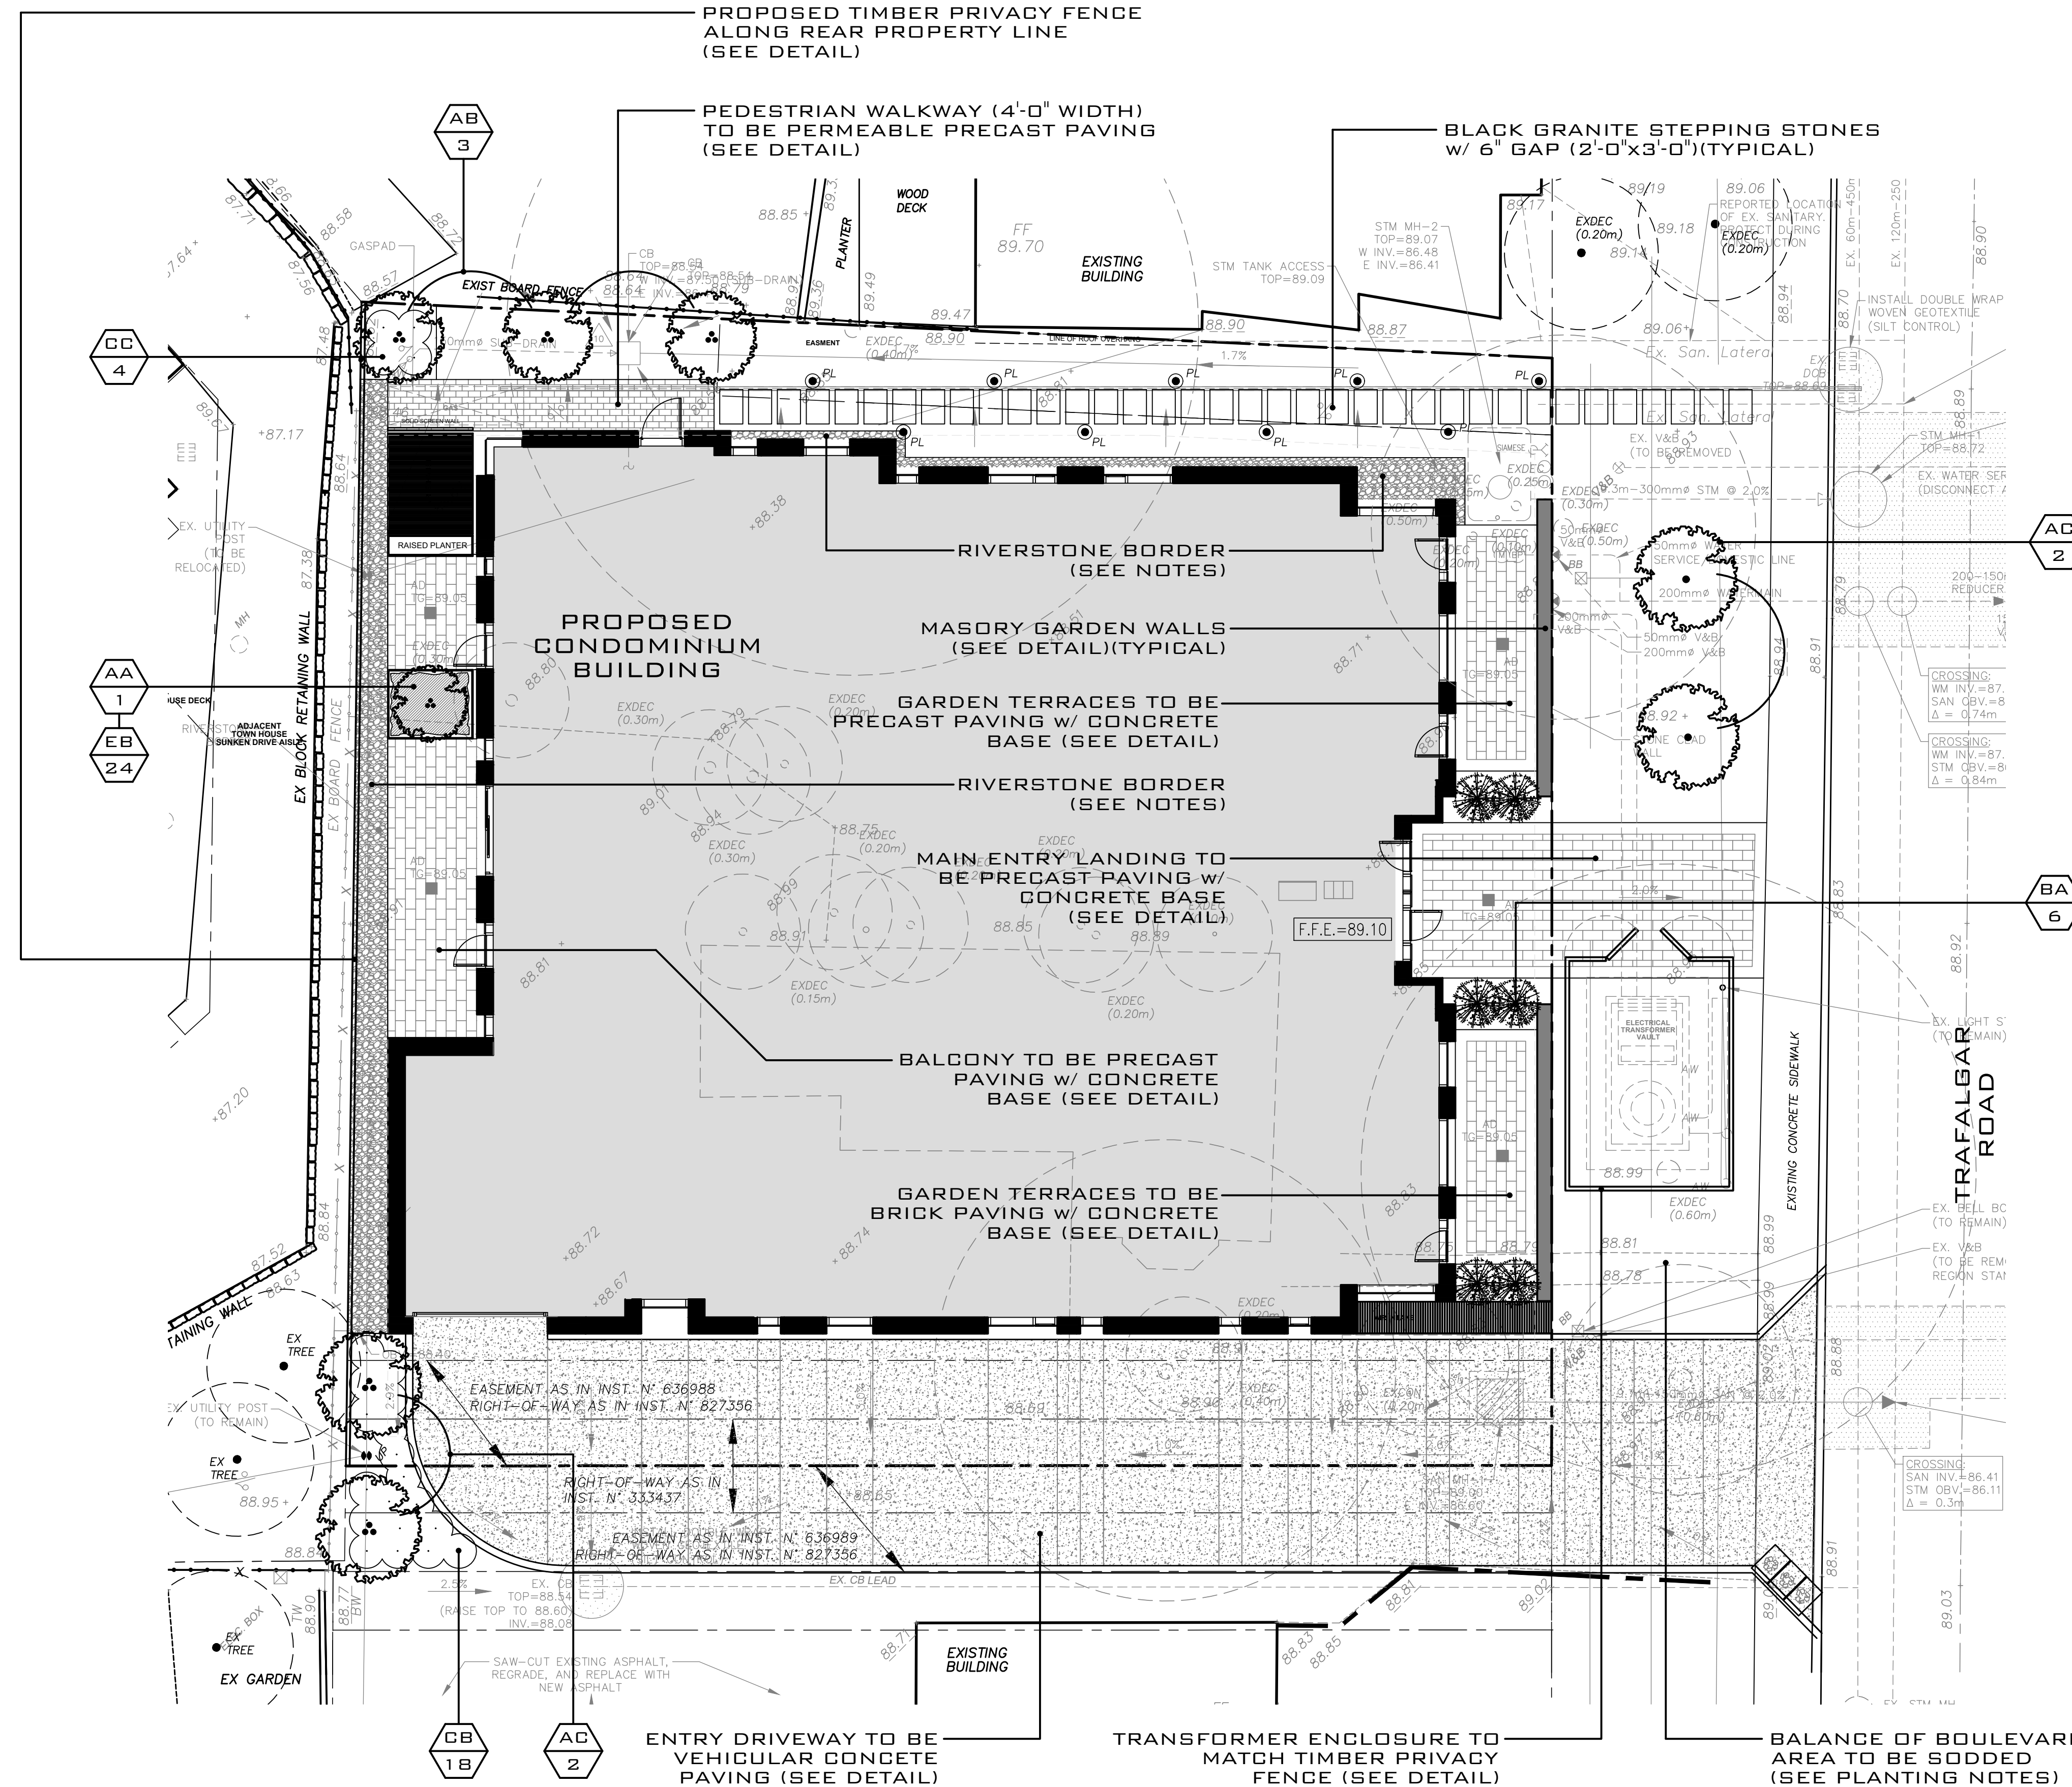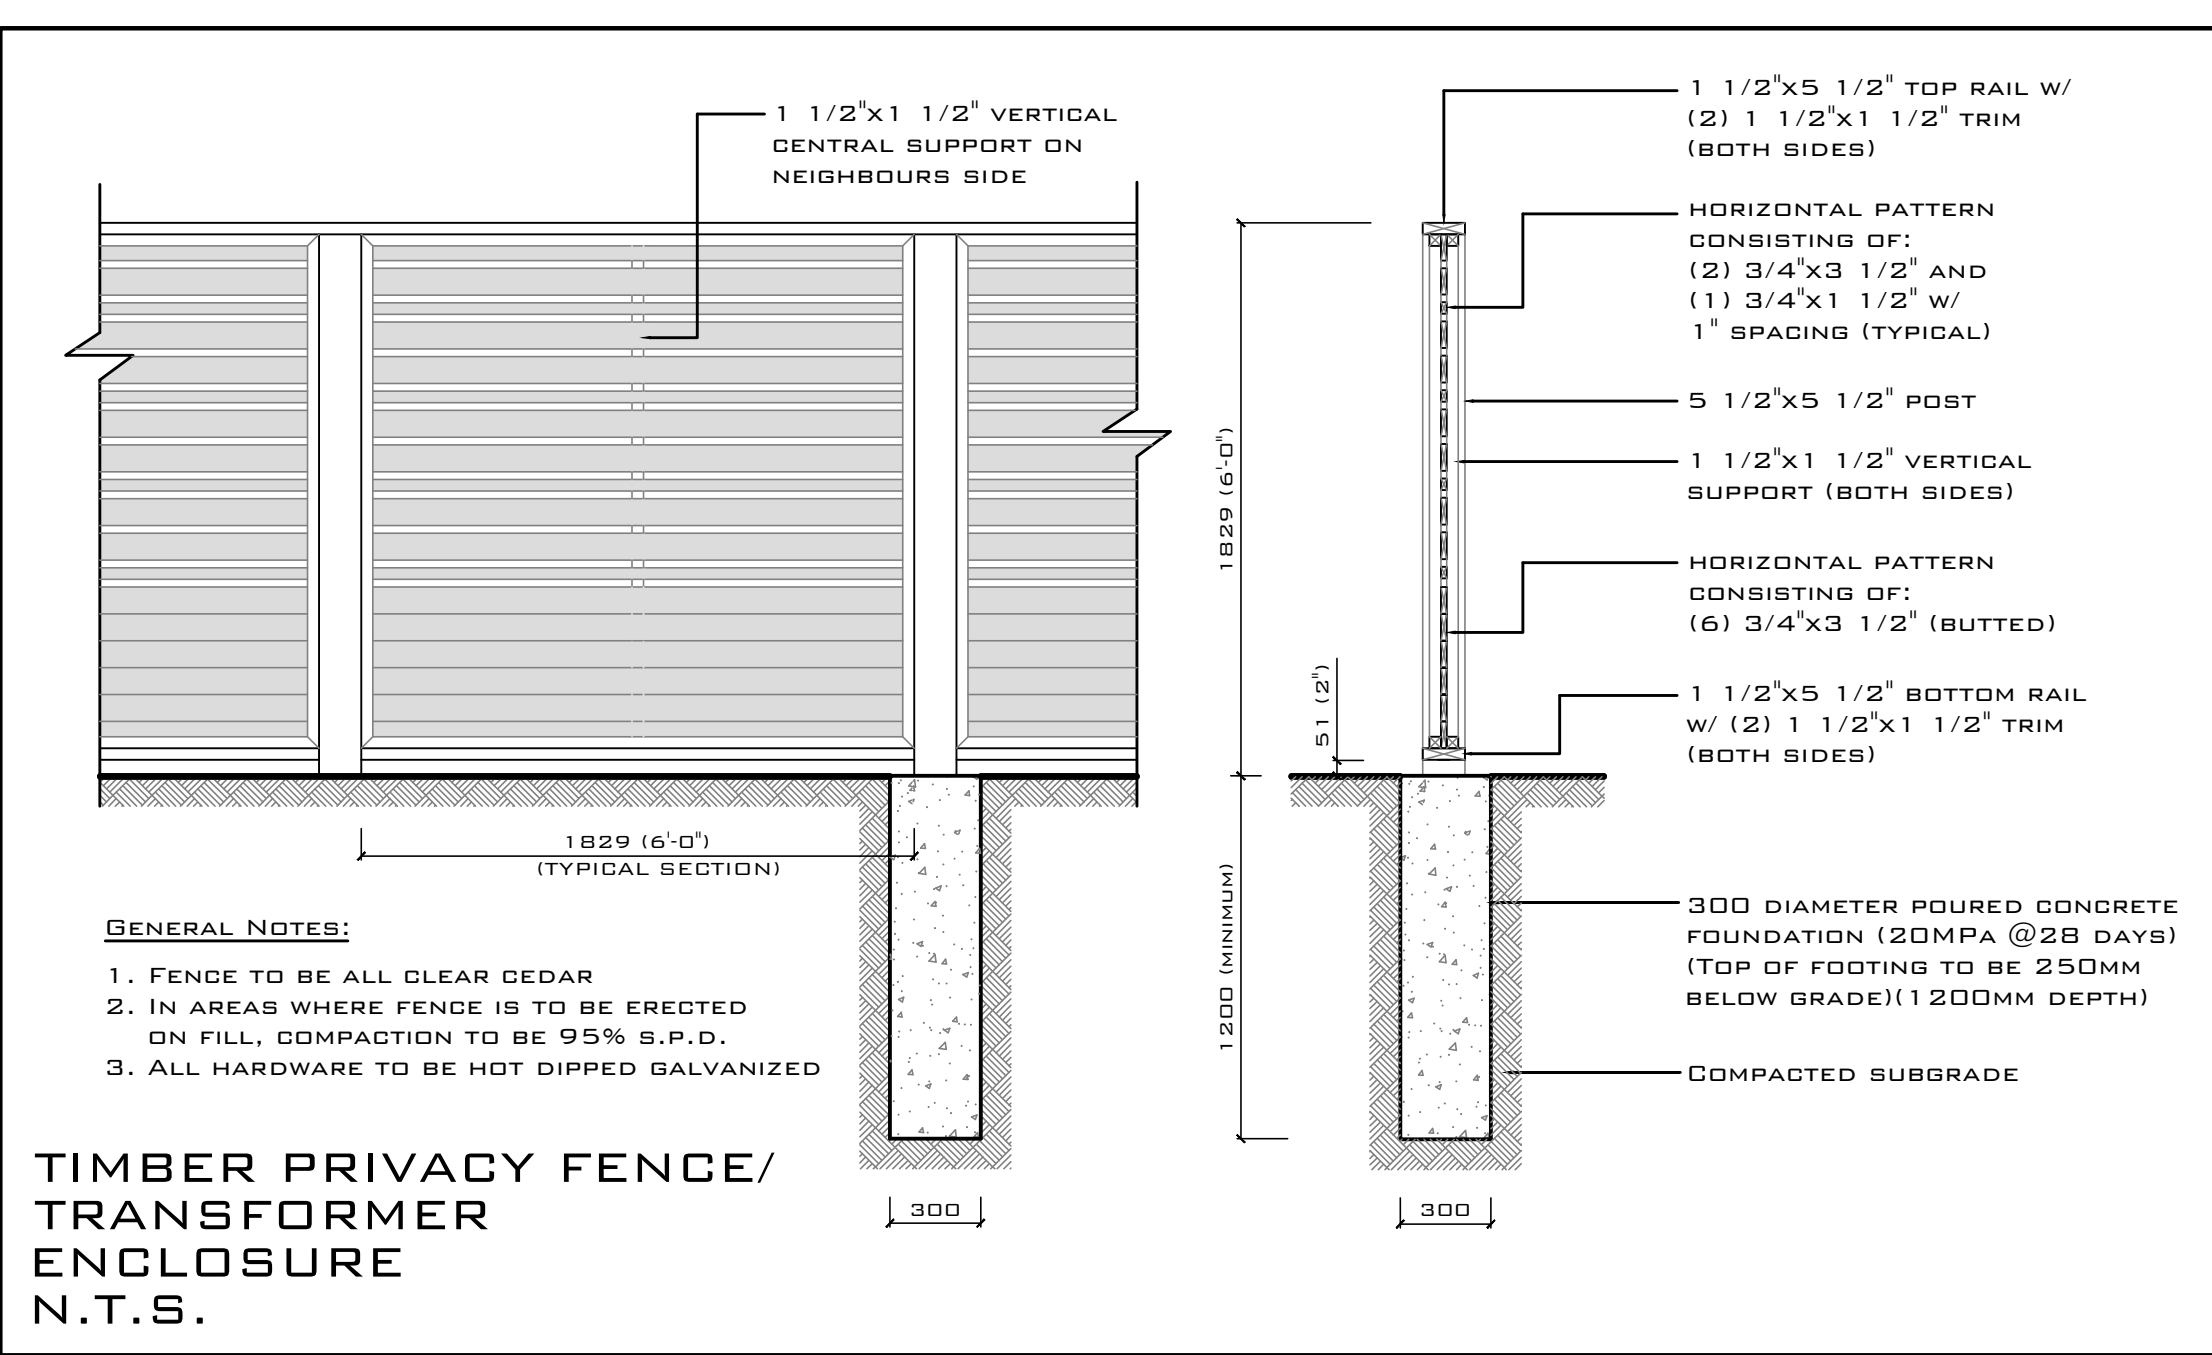

REVISIONS:

DATE	NO.	ITEM	BY
26/04/18	01	ISSUED FOR SITE PLAN APPROVAL	DOB
15/06/18	02	REVISIONS PER S.P.A. COMMENTS	DOB
12/10/18	03	REVISIONS PER BUILDING LAYOUT	DOB
07/01/19	04	REVISIONS PER S.P.A. COMMENTS	DOB
25/03/19	05	LANDSCAPE/TREE CANOPY REVISIONS	DOB
16/03/20	06	PERMEABLE PAVING WALKWAY ADDED	DOB
10/09/20	07	PROPOSED TREE RELOCATED	DOB
09/03/21	08	PROPOSED TREES RELOCATED	DOB
24/02/23	09	REVISIONS PER S.P.A. SUBMISSION	DOB
26/05/25	10	REVISIONS PER S.P.A. SUBMISSION	DOB
23/02/26	11	REVISIONS PER S.P.A. SUBMISSION	DOB
11/03/26	12	REVISIONS PER S.P.A. SUBMISSION	DOB
10/04/26	13	REVISIONS PER S.P.A. SUBMISSION	DOB

PLANT DATE: APR 10/2026

LANDSCAPE ARCHITECTS
LANDSCAPE DESIGN, CONSULTATION & PROJECT MANAGEMENT

DANIEL J. O'BRIEN & associates ltd.

TEL: 905-885-4466
WEB: www.obrienassociates.ca
EMAIL: danielobrien@bellnet.ca

798 BESSBOROUGH DRIVE
OSHAWA, ONTARIO
L1G 4H2

PROJECT:

PROPOSED CONDOMINIUMS
158 TRAFALGAR ROAD
OAKVILLE, ONTARIO

DRAWING:

LANDSCAPE PLAN, PLANT LIST AND CONSTRUCTION DETAILS

DATE: APR 2018	PROJECT NO: 2018-02
DESIGNED: DOB	
DRAWN: RPR	
CHECKED: DOB	DRAWING NO: L1 OF 2
SCALE: 1:100	

