

PLAN 20R-2442
Received and Deposited
Date February 29, 2016
Date March 1, 2016
A. Timbeas
Representative for Land Registrar for the Land Titles Division of Halton Region (No. 20)
Ashraf Rizk, O.L.S.
Ontario Land Surveyor

I require this plan to be deposited under the Land Titles Act.
METRIC: Distances and Coordinates shown on this plan are in meters and can be converted to feet by dividing by 0.3048.

PLAN OF SURVEY OF
PART OF LOT 10
CONCESSION 1,
NORTH OF DUNDAS STREET
TOWN OF OAKVILLE
REGIONAL MUNICIPALITY OF HALTON

J.H. Gelbloom Surveying Limited
Ontario
2016
SCALE 1 : 1000

PLAN 20R-15604
PART I,
NORTH OF DUNDAS STREET

PLAN 20R-4830
PART I,
NORTH OF DUNDAS STREET

PLAN 20R-4361
PART I,
NORTH OF DUNDAS STREET

PLAN 20R-4361
PART II,
CONCESSION 1,
NORTH OF DUNDAS STREET

PLAN 20R-4361
PART II,
CONCESSION 1,
NORTH OF DUNDAS STREET

PLAN 20R-4361
PART II,
CONCESSION 1,
NORTH OF DUNDAS STREET

SCHEDULE

TABLE	DATE OF DEPOSIT	ALL OF PIN
1	1. 2016.3.	24930-0017

LEGEND
 Survey Monument Found
 Survey Monument Set
 2556
 7
 8
 9
 100

BEARINGS AND DISTANCES DERIVED FROM SPECIFIED CONTROL POINTS LISTED IN THE FOLLOWING TABLE, AND ARE REFERENCED TO THE COORDINATE SYSTEM 16° UTM, AD83 OP80.

POINT ID	NORTHING	EASTING
0019633604	4 817 024.432	601 603 436
0081900001	4 850 390.417	602 345.619
0451900009	4 817 193.399	606 198.697

COORDINATES CANNOT BE USED TO RE-ESTABLISH CORNERS OR BOUNDARIES SHOWN ON THIS PLAN.

ROTATE BEARINGS ON THE PLAN OF SURVEY BY MCCOMMELL MALAGAN LTD., DATED OCTOBER 27 1999 (P2), PLAN 20R-4361 (P4) AND PLAN 20R-4242 (P5), 0° 47' 50", COUNTERCLOCKWISE TO COMPARE WITH GRID BEARINGS ON THIS PLAN.


Distances shown on this plan are Ground Distances and can be converted to Grid Distances by multiplying the Common Scale Factor of 0.999701.

Witness Unknown
 P1
 P2
 P3
 P100

PLAN 20R-15604
PART I,
NORTH OF DUNDAS STREET

PLAN 20R-4830
PART I,
NORTH OF DUNDAS STREET

PLAN 20R-4361
PART I,
NORTH OF DUNDAS STREET

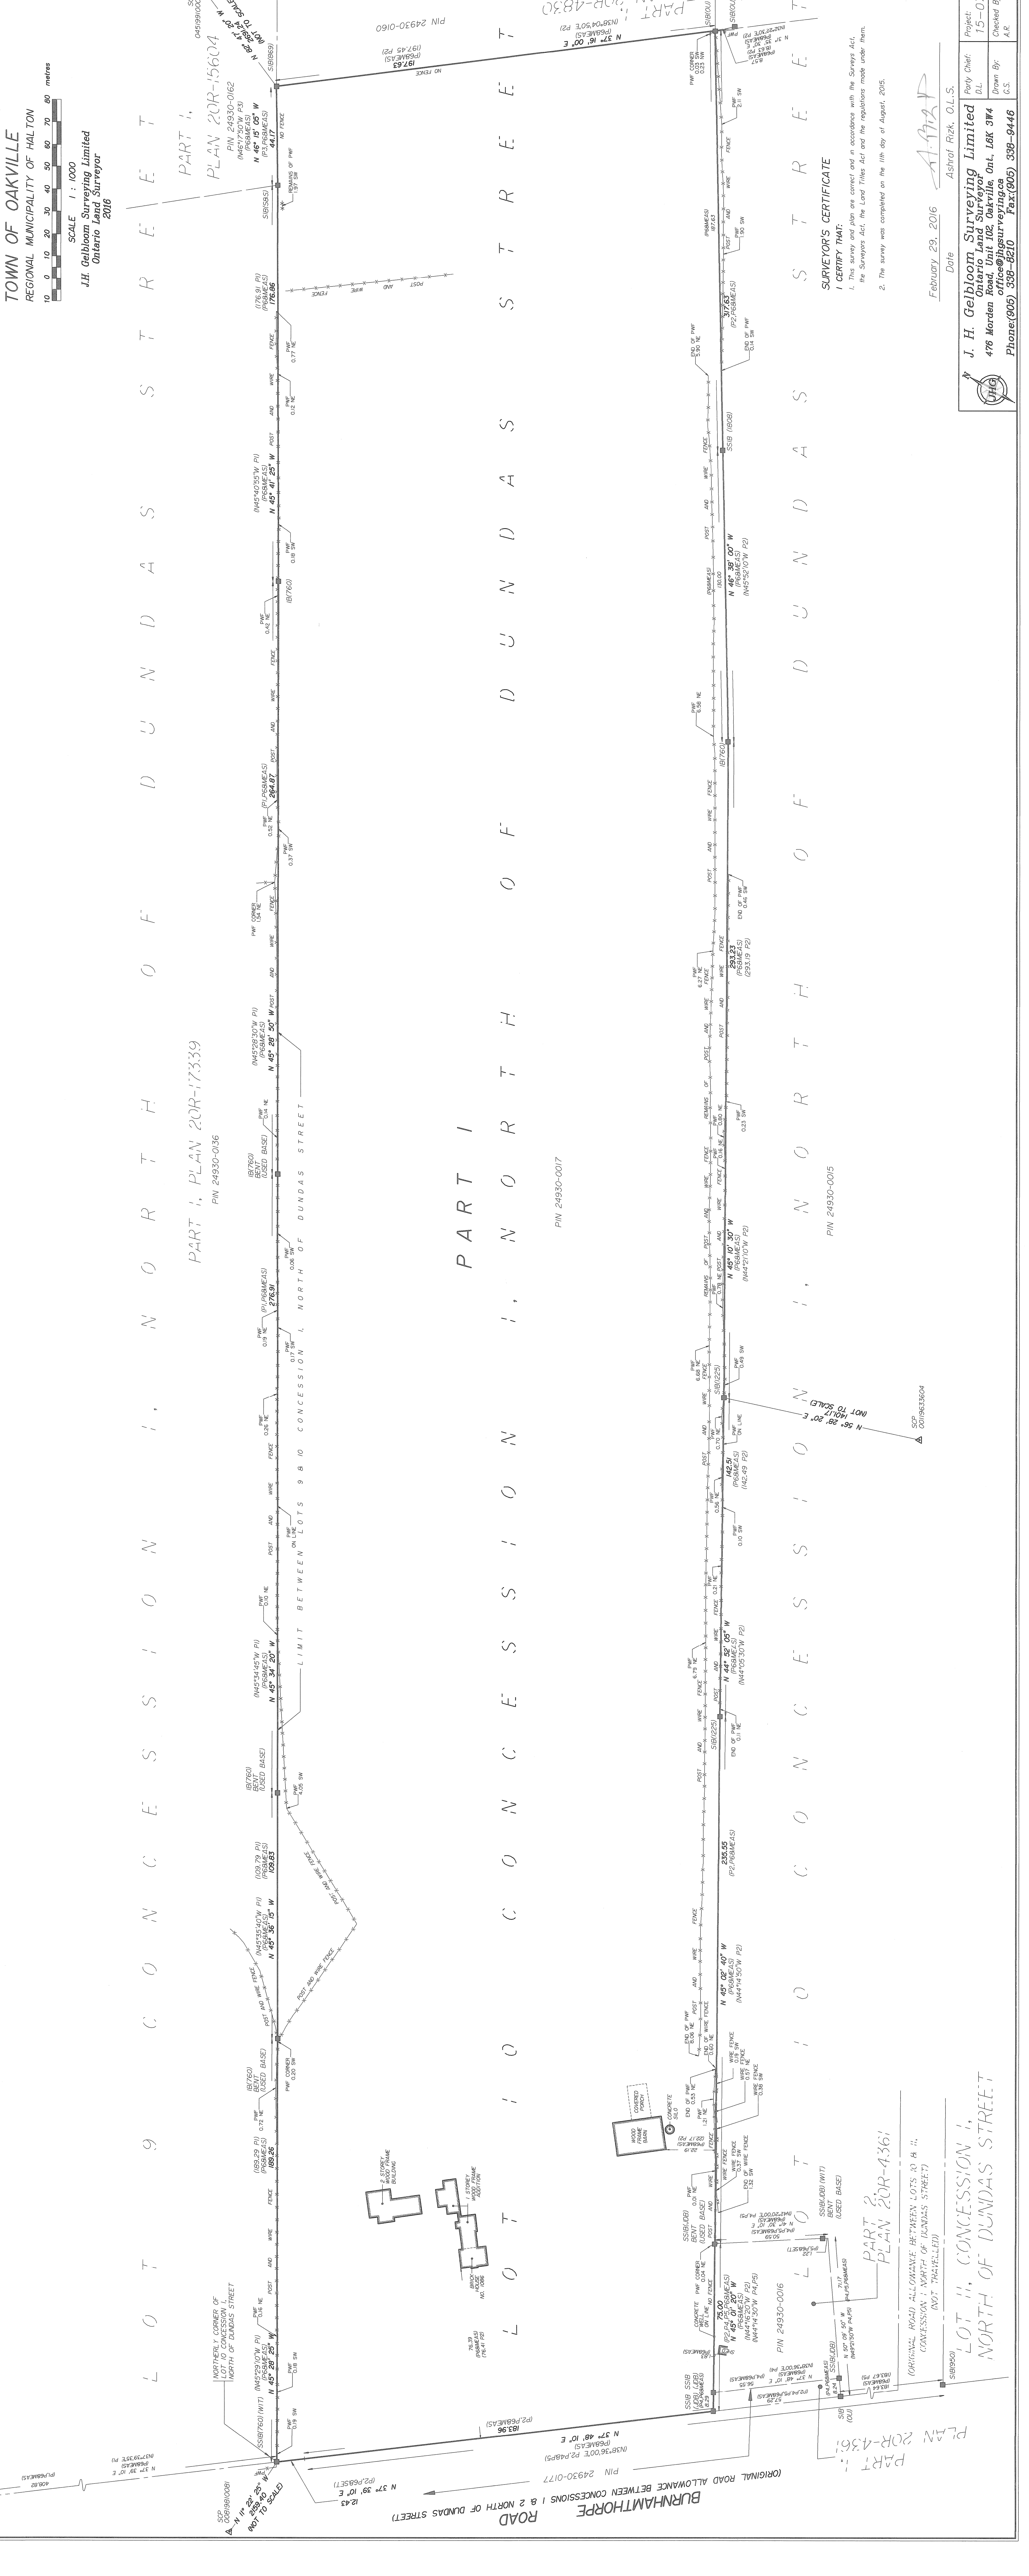

February 29, 2016
 Date
 Ashraf Rizk, O.L.S.
 J. H. Gelbloom Surveying Limited
 Ontario Land Surveyor
 476 Morden Road, Unit 102 Oakville, Ont, L6K 3W4
 office@jhgsurveying.ca
 Phone: (905) 338-8210 Fax: (905) 338-8446
 Project: 15-076
 D.L.
 Drawn By: [Signature]
 Checked By: [Signature]