
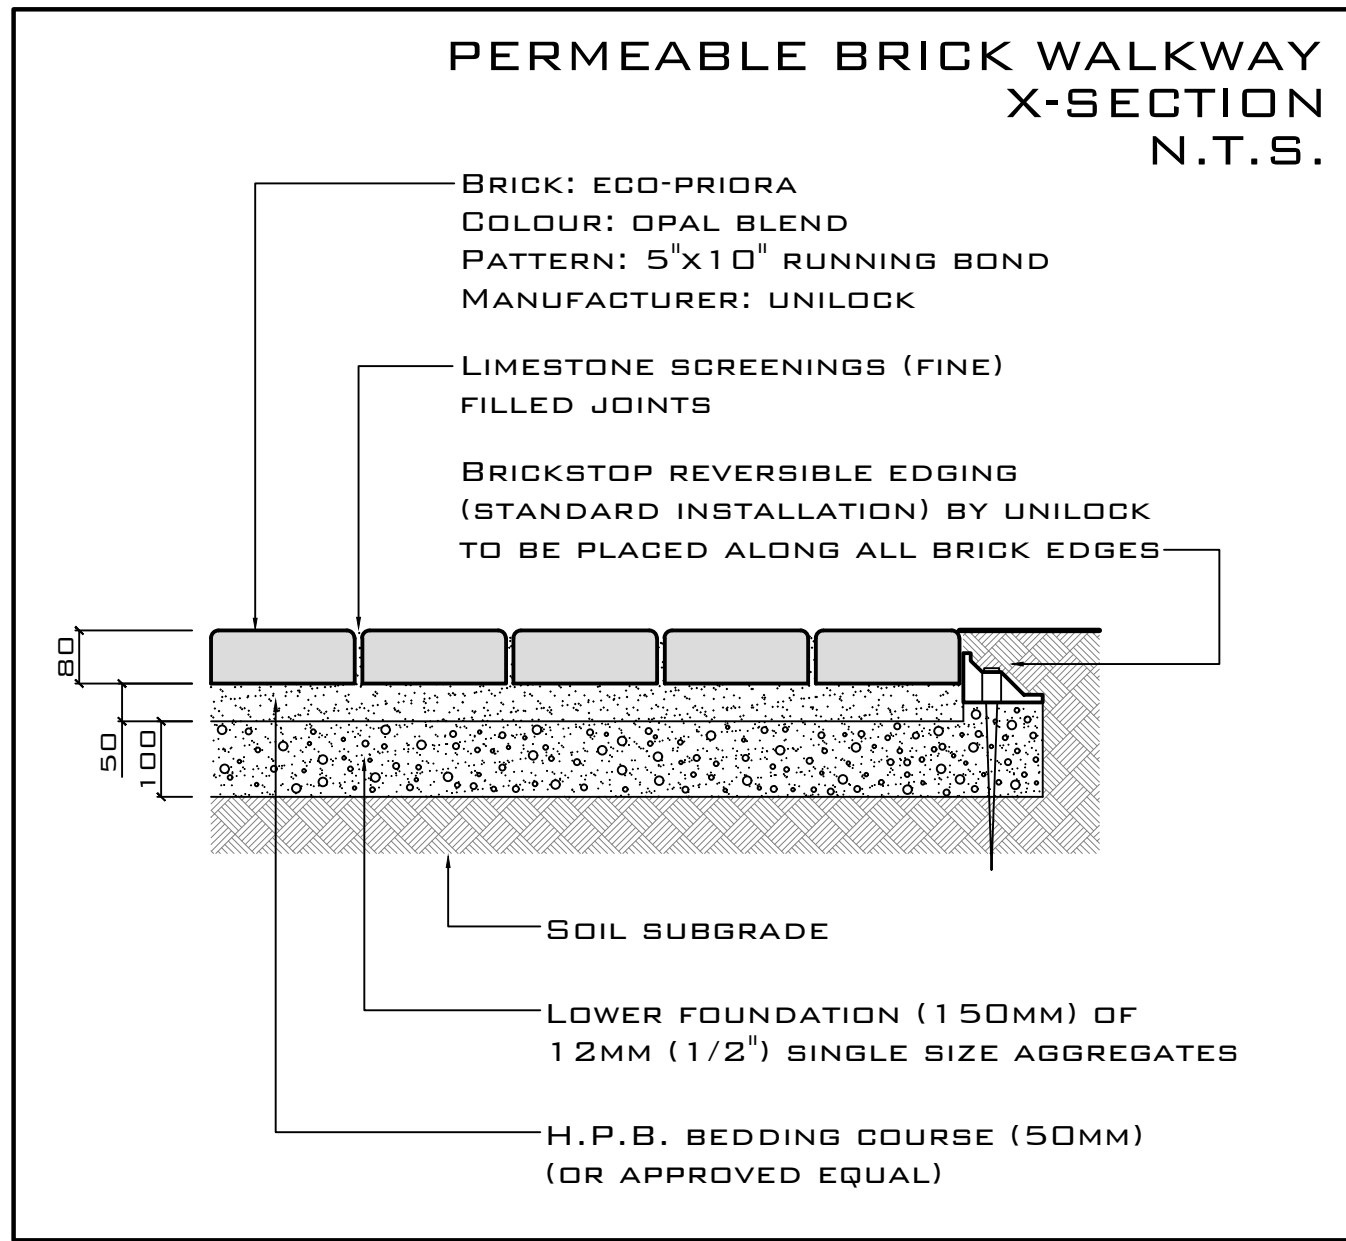


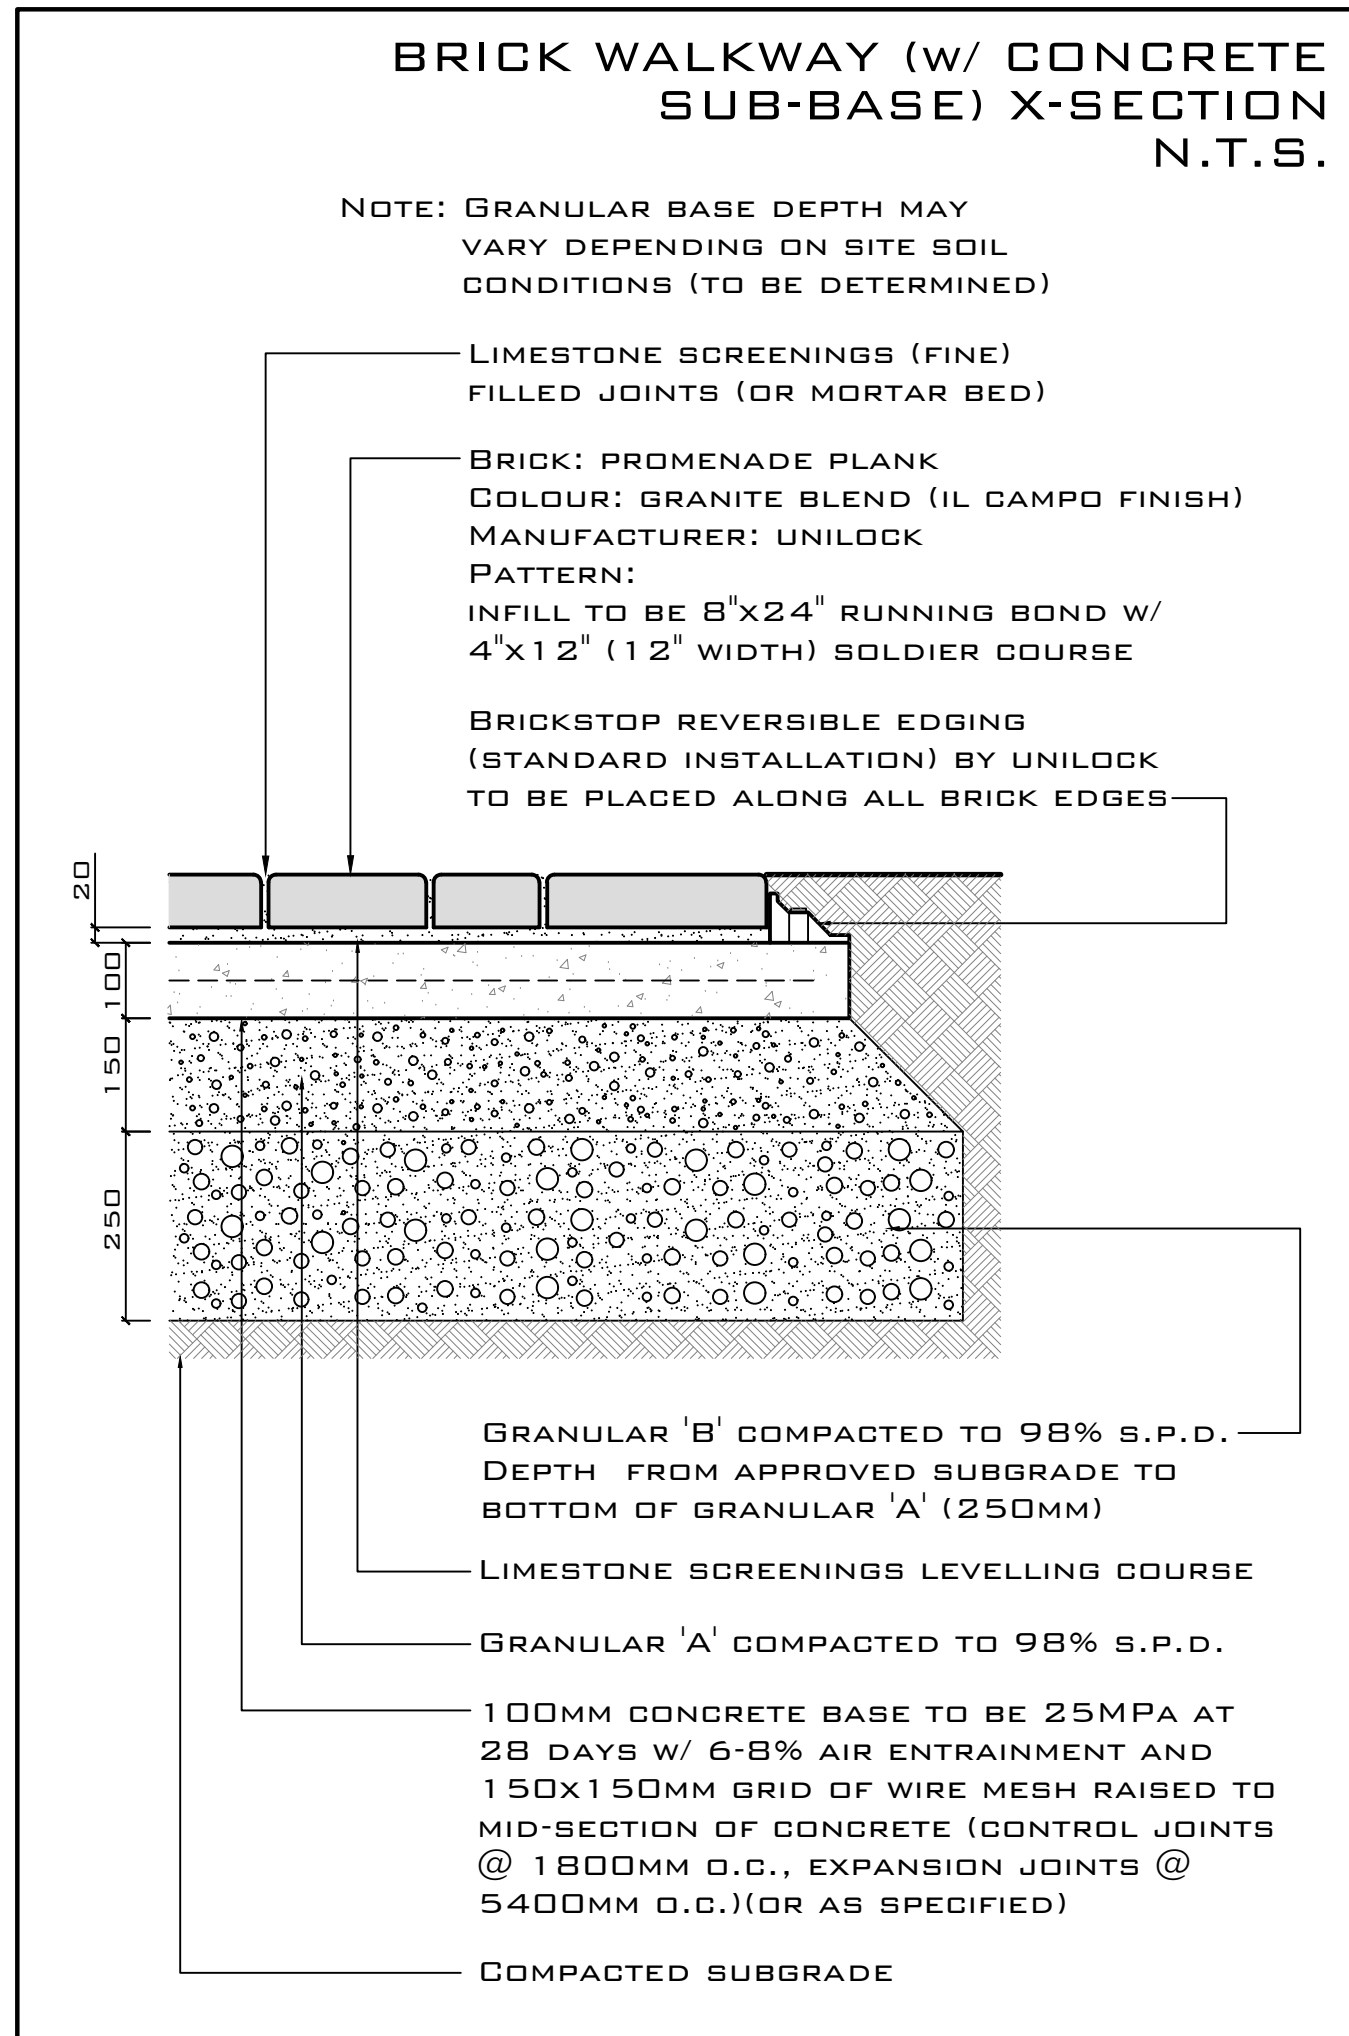

THE FOLLOWING FIXTURES TO BE AS SUPPLIED BY (OR APPROVED EQUAL):

ESTATE LIGHTING SUPPLY 190 HIGHWAY #7 WEST UNITS #53-54 BRAMPTON, ONTARIO, L7A 1A2 (TEL) 877-874-1022


THE FOLLOWING FIXTURES TO BE AS MANUFACTURED BY (OR APPROVED EQUAL):

CAST LIGHTING LLC (TEL) 800-914-CASST (WEB) WWW.CAST-LIGHTING.COM

PL - GOOSENECK #MR-16 AREA/PATH


ELECTRICAL LEGEND/NOTES:

PL - GOOSENECK #MR-16 AREA/PATH

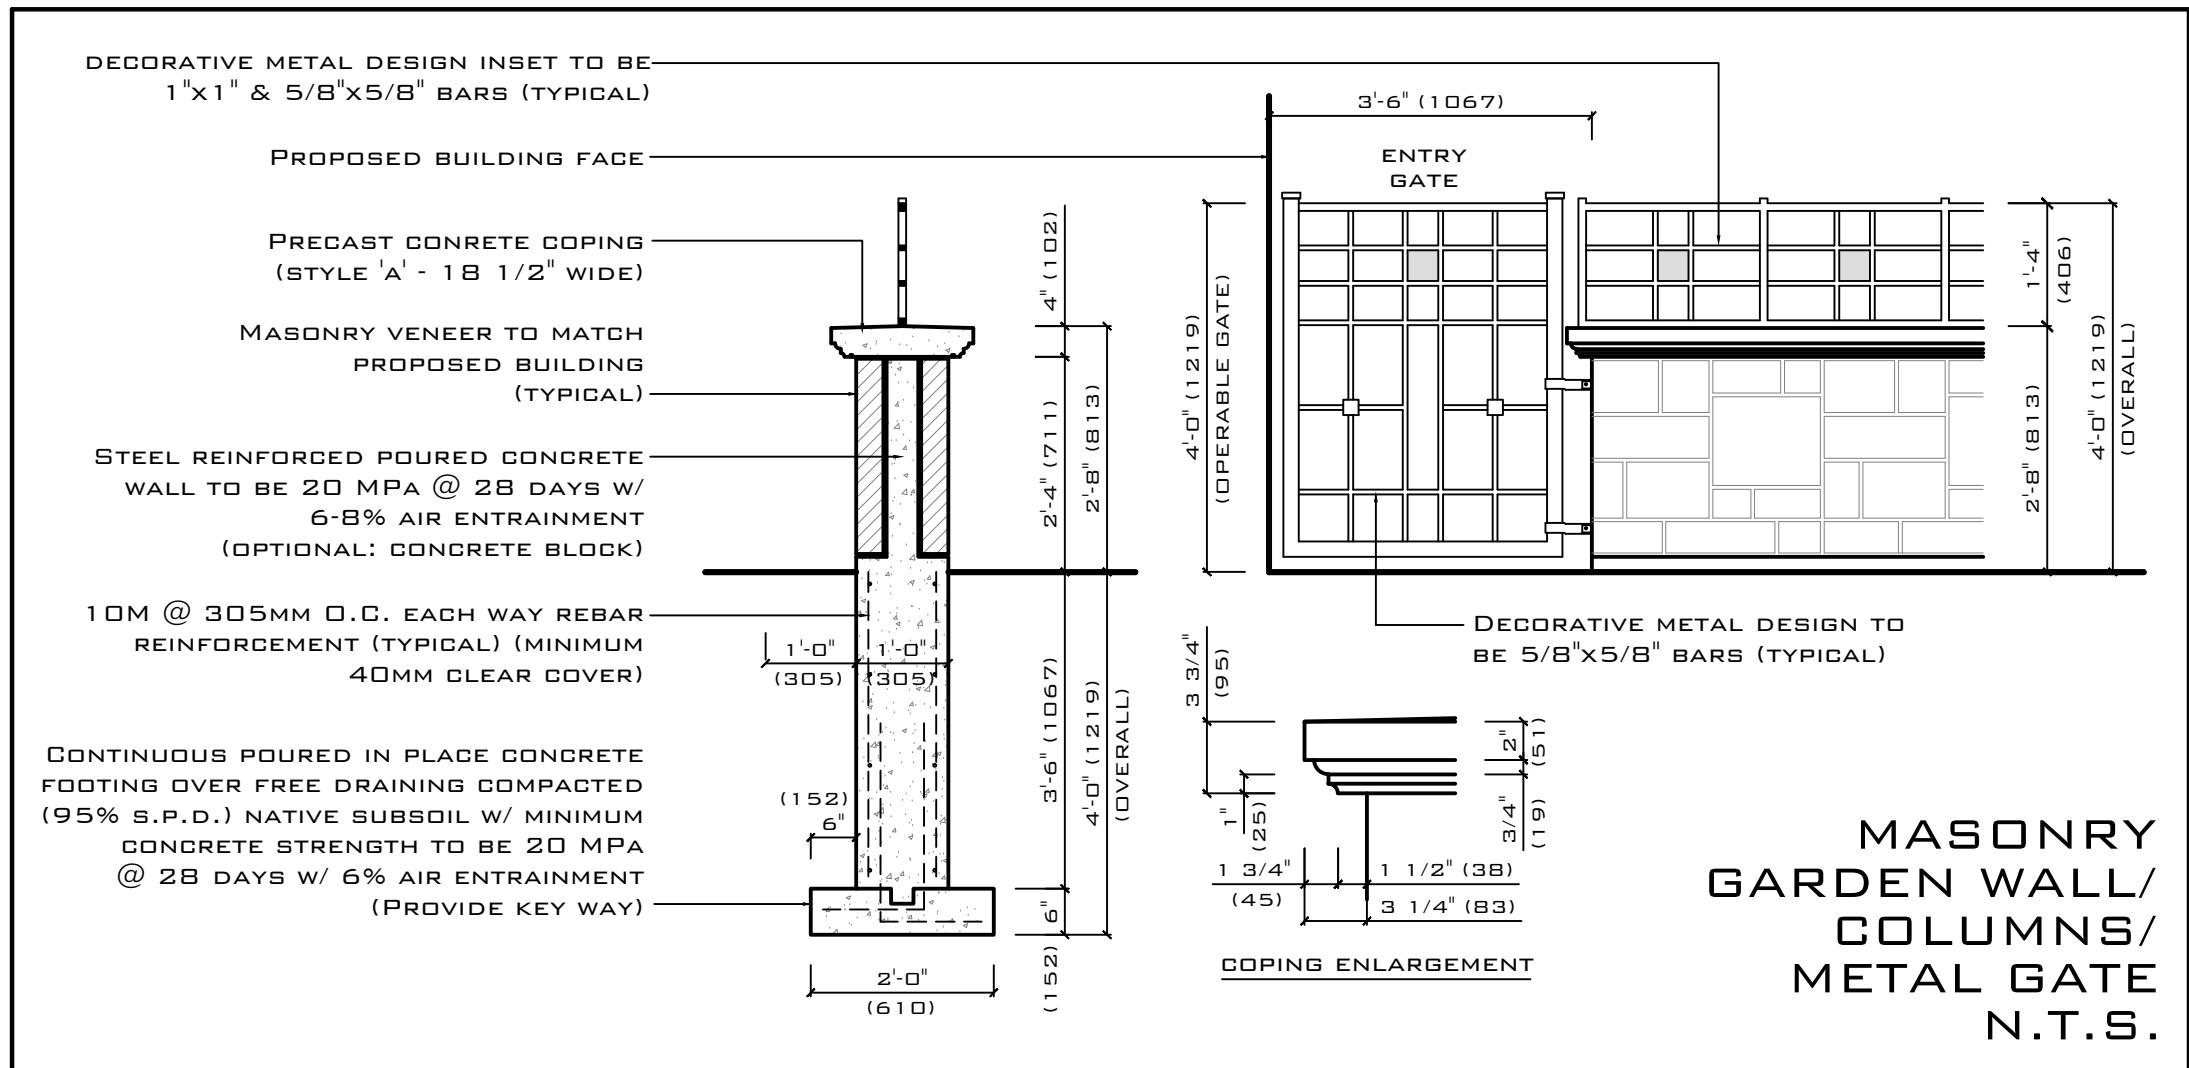

PLANT LIST

KEY	BOTANICAL NAME	COMMON NAME	NUM	SIZE	COND	REMARKS
AA	FASUS SYLVATICA 'RED OBELISK'	RED OBELISK BEECH	3	60MM GAL		
AB	GYMNOCLADUS DIDICUS	KENTUCKY COFFEE TREE	3	100MM GAL		
AC	LIRIODENDRON TULIPIFERA	TULIP TREE	1	100MM GAL		
AD	HALUS 'RINK'	RINKI CRABAPPLE	1	60MM GAL		
BA	HYDRANGEA MACROPHYLLA 'NIKKO BLUE'	NIKKO BLUE HYDRANGEA	8	800x HT		
CA	HEDERA HELIX 'BALTICA'	BALTIC ENGLISH IVY	140	POTTED		
CB	HEMEROCALLIS 'HYPERION'	HYPERION DAYLILIES	36	POTTED		

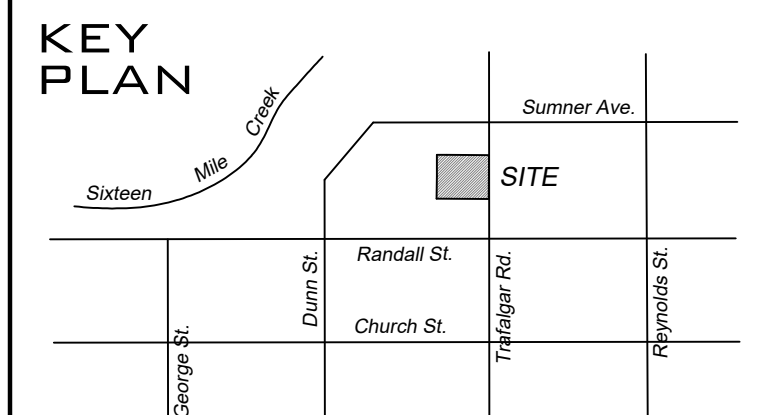

PLANTING NOTES:

ALL AREAS NOTED AS SODDED TO HAVE #1 NURSERY GROWN SOD W/ 200MM DEPTH (MINIMUM) TOPSOIL (TYPICAL)

ALL PLANTED AREAS TO HAVE 300MM DEPTH (MINIMUM) OF PLANTING MIX, AND 100MM DEPTH (MINIMUM) OF BLACK COMPOSTED BARK MULCH BY GRO-BARK LIMITED (NOTE: SODD LEVEL TO BE 100MM ABOVE SOD LEVEL)

RIVERSTONE NOTES:

AREA NOTED AS RIVERSTONE BORDER TO HAVE 3"-5" DIAMETER RIVERSTONE WITH LANDSCAPE FILTER FABRIC (CONTINUOUS)

REVISIONS:

DATE	NO.	ITEM	BY
26/04/18	01	ISSUED FOR SITE PLAN APPROVAL	DOB
15/06/18	02	REVISIONS PER S.P.A. COMMENTS	DOB
12/10/18	03	REVISIONS PER BUILDING LAYOUT	DOB
07/01/19	04	REVISIONS PER S.P.A. COMMENTS	DOB
25/03/19	05	LANDSCAPE/TREE CANOPY REVISIONS	DOB
16/03/20	06	PERMEABLE PAVING WALKWAY ADDED	DOB
10/09/20	07	PROPOSED TREE RELOCATED	DOB
09/03/21	08	PROPOSED TREES RELOCATED	DOB

SEE TABLE BELOW FOR HEIGHT AND SPACING (NOTE: PANELS MAY BE CUT TO SUIT)

PANEL HEIGHT ***	PANEL WIDTH	POST SETTING (CENTRE TO CENTRE)
914mm (36")	2298mm (90 1/2")	2432mm (95 3/4")
1219mm (48")	1785mm (69 1/2")	1899mm (74 3/4")
1524mm (60")		
1829mm (72")		
2134mm (84")		
2439mm (96")		
2744mm (108")		
3049mm (120")		
3354mm (132")		

SPECIFICATIONS:

POSTS, RAILS, & PICKETS: COLD FORMED STEEL TURNING INTERIOR & EXTERIOR GALVALUME™ COATING CHROMATE CONVERSION COATING ELECTROSTATICALLY APPLIED THERMALLY BONDED POLYESTER POWDER COATING - MINIMUM FILM THICKNESS 2.5 mils

POSTS: 76mm x 76mm (3"x3") 14 GAUGE, SS40 OR SS41 40

POST FLANGES: 203mm x 203mm (8"x8") x 13mm (1/2") OR 254mm x 254mm (10"x10") x 13mm (1/2")

POST CAP: PYRAMID OR BALL

RAILS: 38mm x 64mm (1 1/2" x 2 1/2"), 16 GAUGE

PICKETS: 19mm x 38mm (3/4" x 1 1/2"), 16 GAUGE

FITTINGS: 12 GAUGE STAMP FORGED FACTORY FINISH AS ABOVE

WELDS: STAINLESS STEEL

COLORS: STANDARD COLORS ARE BLACK, SEMI-BLACK, BROWN, GREEN, WHITE & FOREST GREEN

CUSTOM COLORS AVAILABLE UPON REQUEST

WARRANTY: 5 YEAR MAINTENANCE FREE

NOTE: ALL TYPE OF GATES AVAILABLE

TAMPER PROOF HAT AVAILABLE

E-COAT PROTECTION AVAILABLE UPON REQUEST


COMMENTS:

TITLE: IRON EAGLE II SERIES CANADIAN EAGLE

DRAWING NO.: C-01

IRON EAGLE INDUSTRIES INC. 1256 CARDIFF BLVD, MISSISSAUGA, ONT. L4X 1L7 TEL: 905-670-2558 FAX: 905-670-2538 www.ironagleind.com

- METAL RAILING/SAFETY FENCE NOTES:**
- MANUFACTURER: IRON EAGLE INDUSTRIES
 - MODEL: CANADIAN EAGLE (IRON EAGLE II)
 - HEIGHT: 4'-0" (1219MM)
 - POST CAP: PYRAMID
 - COLOR: BLACK

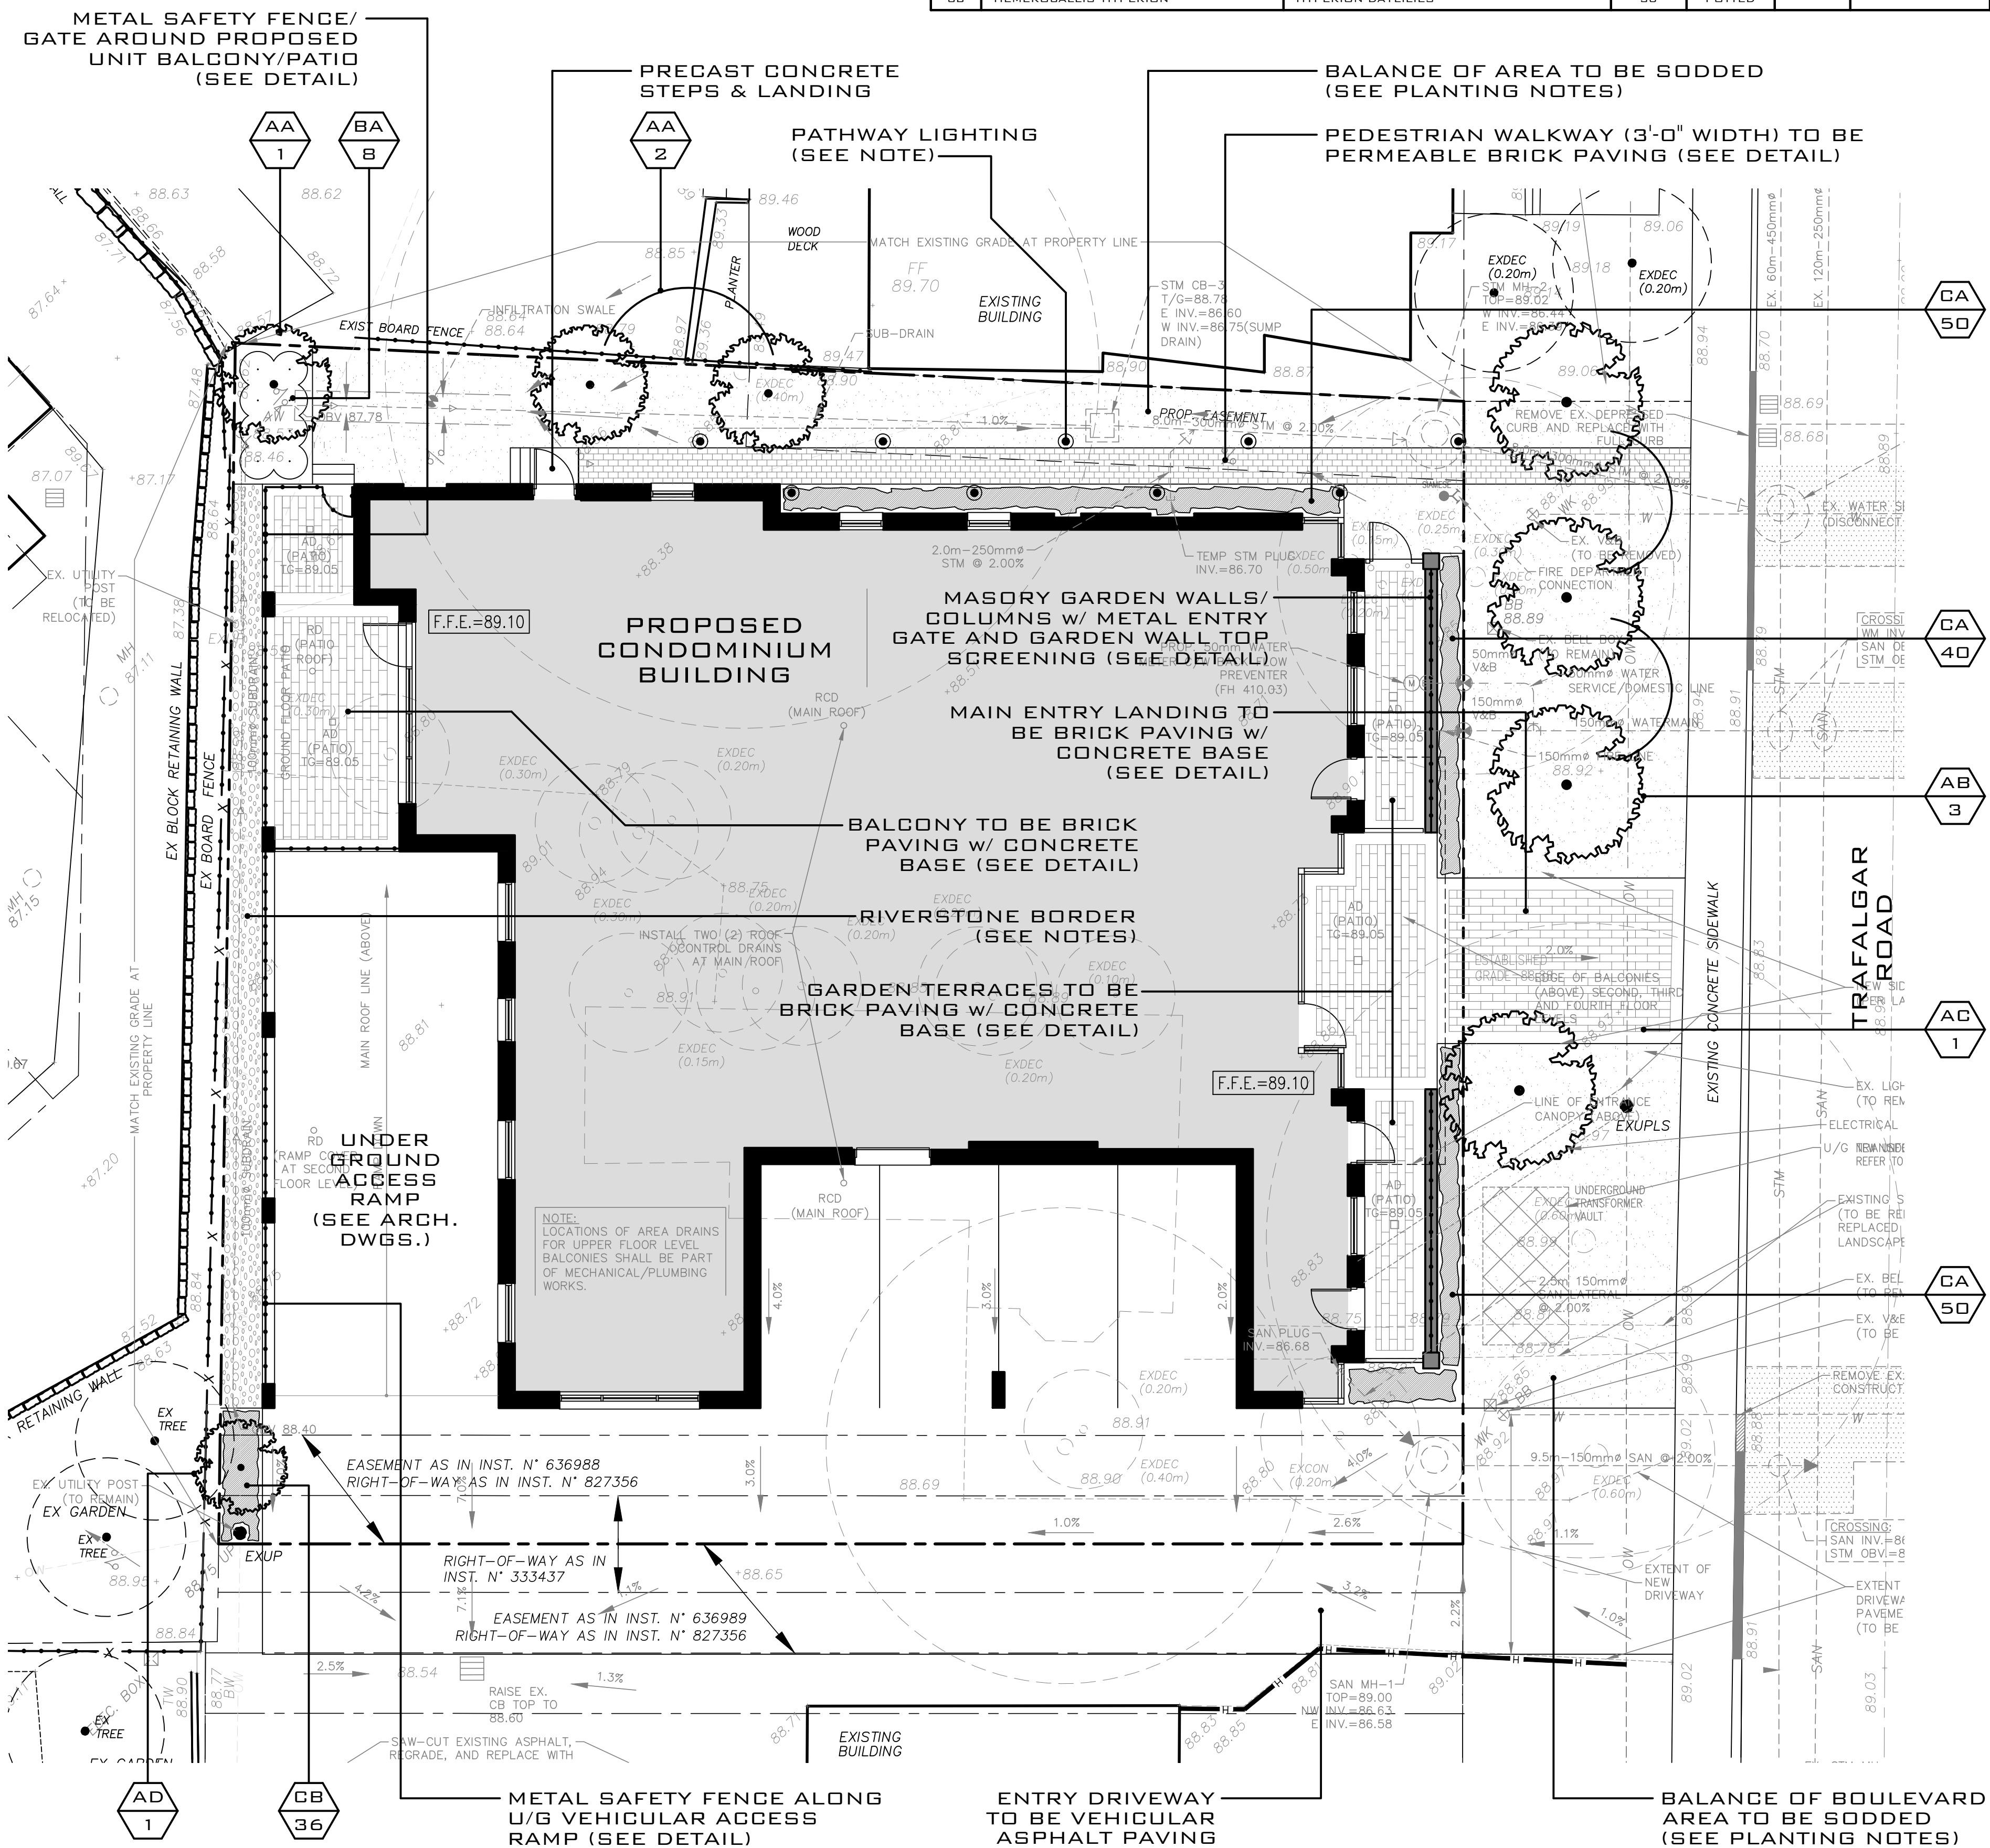

PLT09/03/21

ASSOCIATION OF LANDSCAPE ARCHITECTS

LANDSCAPE ARCHITECT

DANIEL J. O'BRIEN & associates Ltd.

DANIEL J. O'BRIEN & associates Ltd.

798 BESSBOROUGH DRIVE OSHAWA, ONTARIO L1G 4H2

TEL: 905-885-4466 WEB: www.obrienassociates.ca EMAIL: danielobrien@bellnet.ca

PROJECT:

TRAFALGAR OAKS CONDOMINIUMS

158 TRAFALGAR ROAD

OKVILLE, ONTARIO

DRAWING:

LANDSCAPE PLAN, PLANT LIST AND CONSTRUCTION DETAILS

DATE: APR 2018	PROJECT NO:
DESIGNED: DOB	2018-02
DRAWN: RPR	
CHECKED: DOB	DRAWING NO:
SCALE: 1:100	L1 OF 2