


Contractor shall check all dimensions on the work and report any discrepancy to the Landscape Architect before proceeding. All drawings and specifications are the property of the Landscape Architect and must be returned at the completion of the work. This drawing is not to be used for construction until signed by the Landscape Architect.

Key Plan

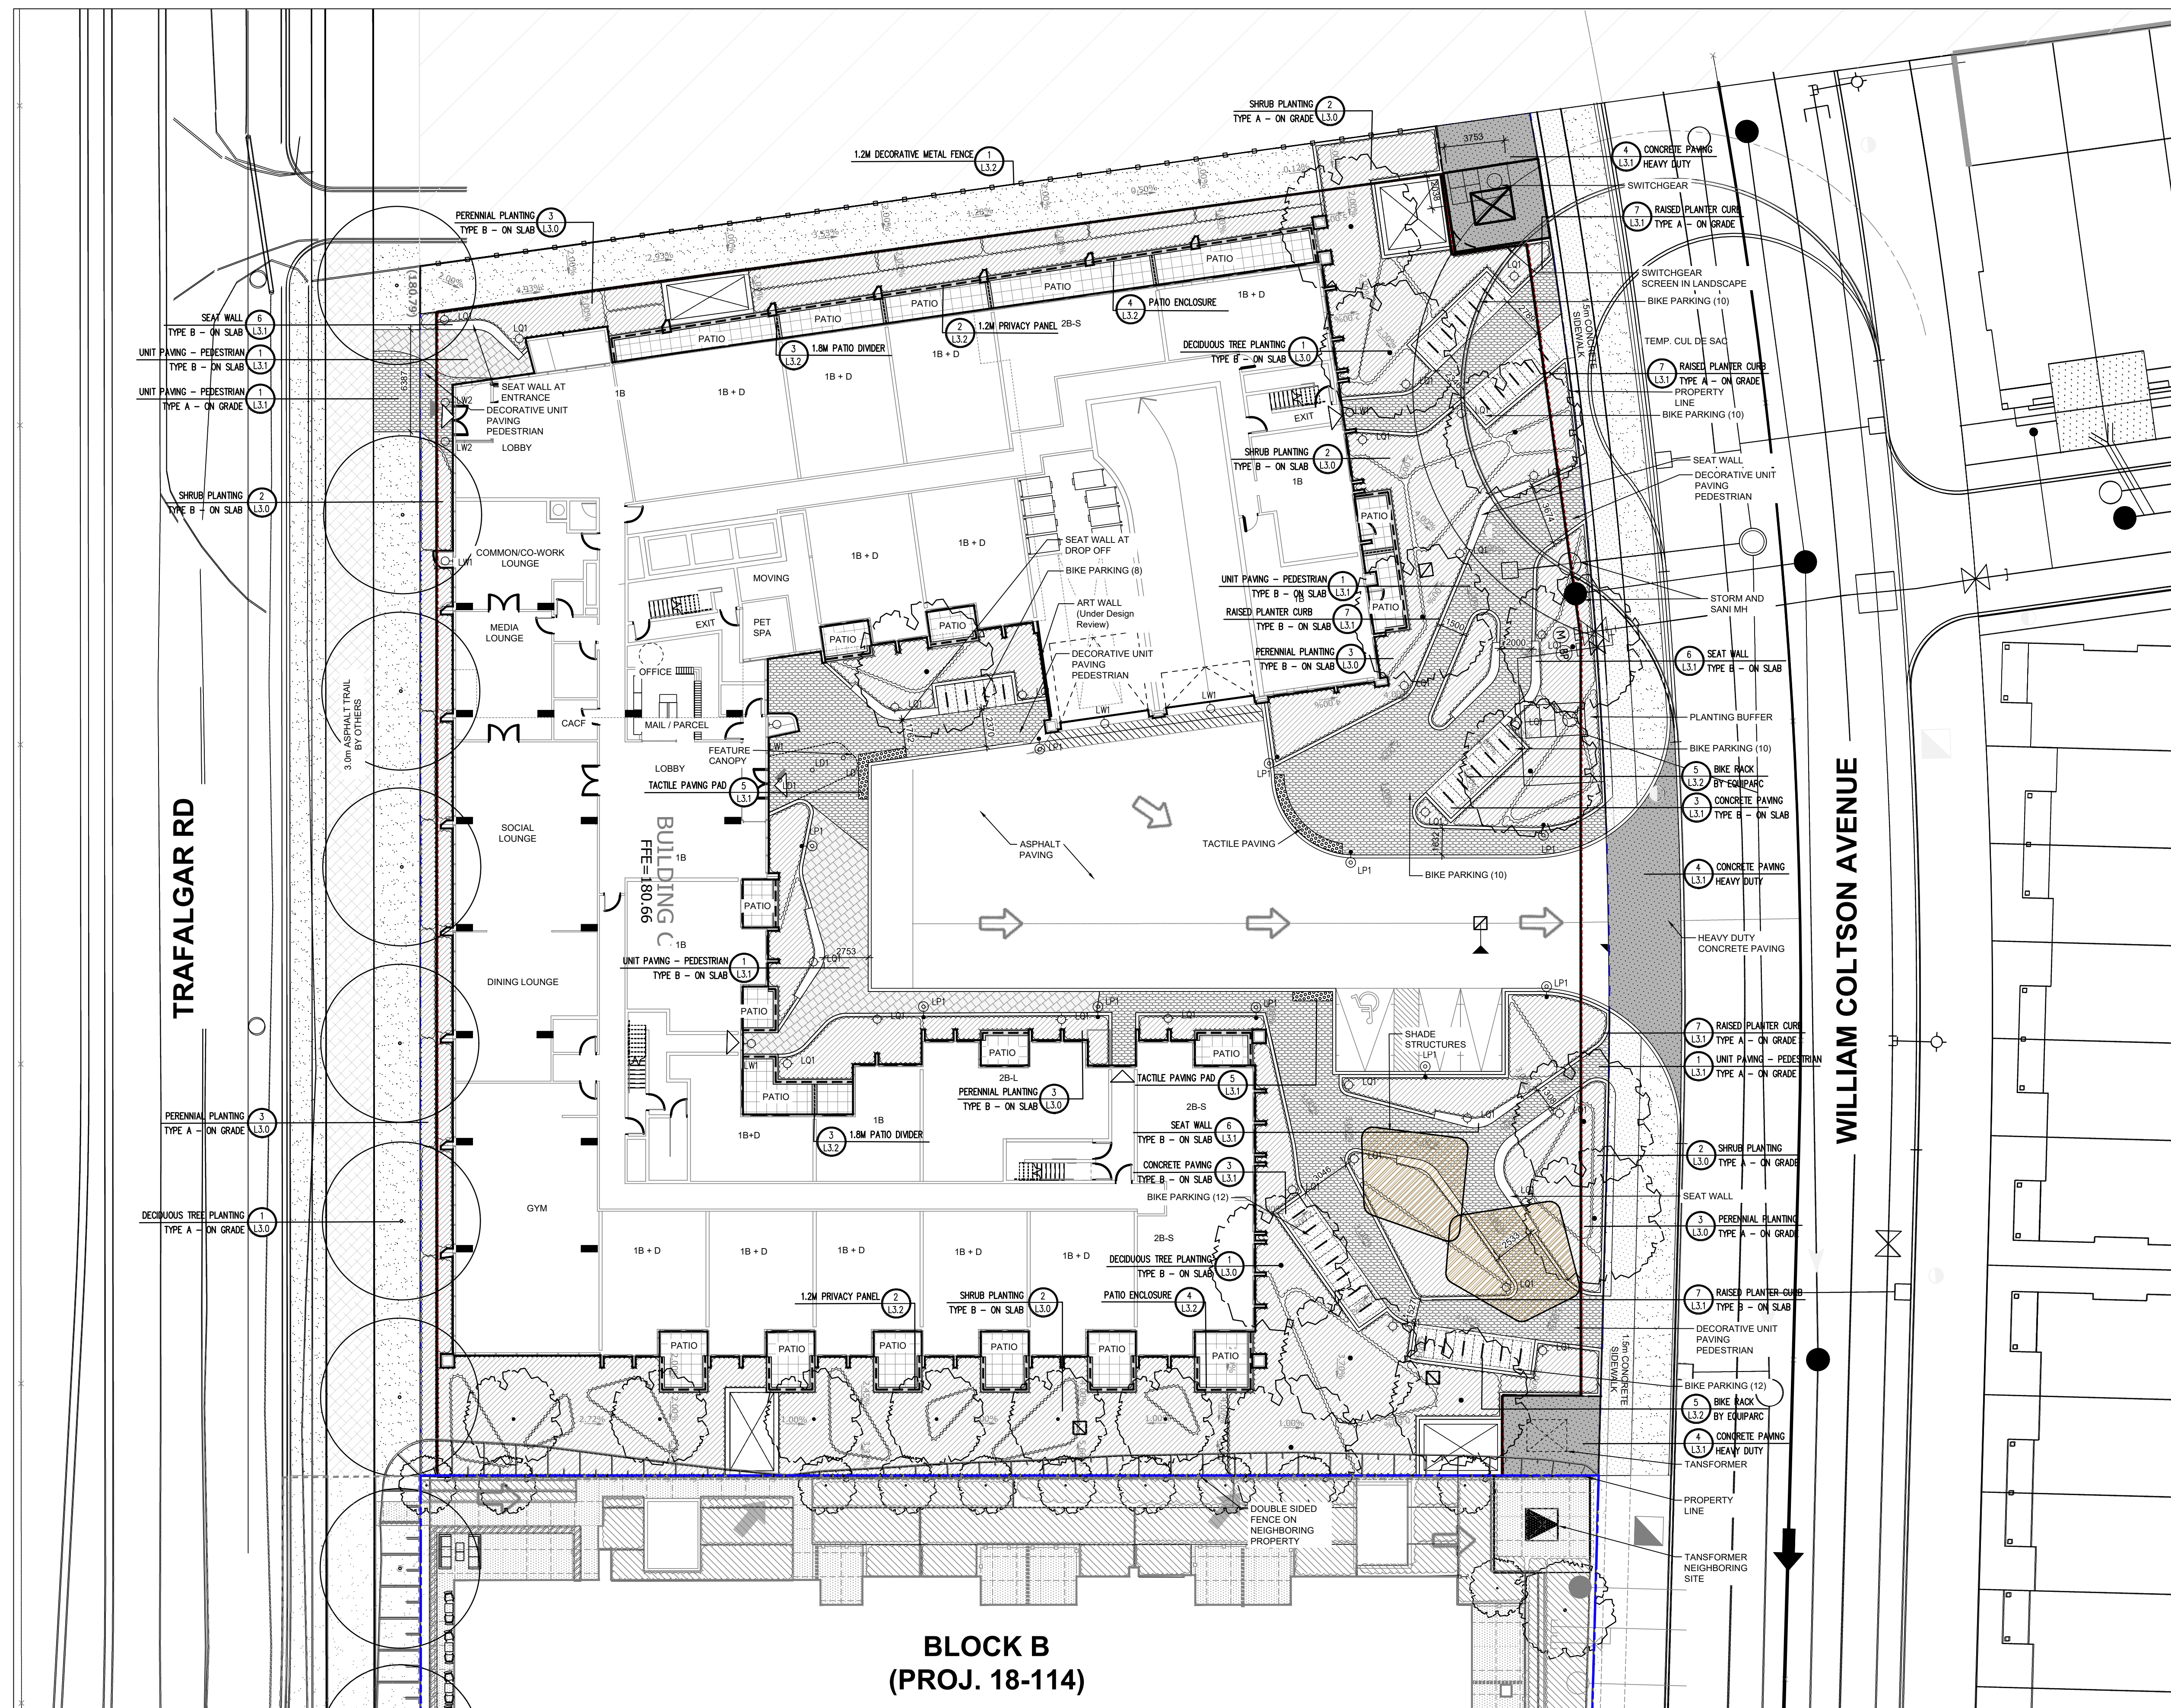


**LEGEND**

- PROPERTY LINE
- LIMIT OF SLAB
- WOOD PRIVACY RAILING 1.2HT
- WOOD PRIVACY PANEL 1.8HT
- DECORATIVE METAL FENCE 1.2HT
- SURFACE TREATMENT
- UNIT PAVING TYPE 1: TECO BLOC Under Design Review SIZE: 100 X 150 X 450 PATTERN: RUNNING BOND
- UNIT PAVING TYPE 2: HEXA 100 BY TECO BLOC SIZE: 100 X 230 X 385 PATTERN: HEXAGON PATTERN
- CONCRETE PAVING (PEDESTRIAN)
- EXPANSION JOINT - 6000mm O/C SAW CUT - 1500mm O/C
- HEAVY DUTY CONCRETE PAVING
- ASPHALT PAVING - MULTI USE TRAIL
- SITE FURNISHINGS
- PROPOSED TRASH RECEPTACLE
- PROPOSED BIKE RACK
- SITE LIGHTING
- L01 CEILING LIGHT
- LW1 WALL SCONCE LIGHT
- LW2 WALL SCONCE LIGHT
- LP1 LIGHT POLE
- L01 LIGHT BOLLARD
- FOR ALL LIGHTING REFER TO ELEC. CONSULTANT PLANS
- DETAIL KEY
- 5-1 DETAIL NO.
- 0-2 SHEET NO.
- 1) FOR ALL SITE GRADING REFER TO CIVIL PLANS

No.	Description	Date
1	Issued for SPA 1 Submission	Dec. 10/21

City Approval Stamp

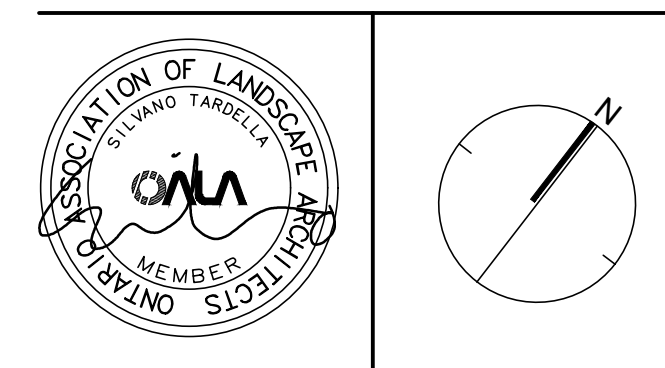

**NAK**  
design strategies

421 RONCESVALLES AVENUE, TORONTO, ON M6R 2N1 CANADA  
T 416.340.8700 F 416.340.7100 [NAKDESIGNSTRATEGIES.COM](http://NAKDESIGNSTRATEGIES.COM)

Project

**OAKVILLE  
BLOCK 14**


Title  
**LAYOUT AND SURFACE  
TREATMENT PLAN**

Date	Oct. 06, 2021	Sheet	
Scale	1:200		
Drawn	TFG		
Checked	PD		
Job No.	21207		

**L1.0**

**BLOCK B  
(PROJ. 18-114)**



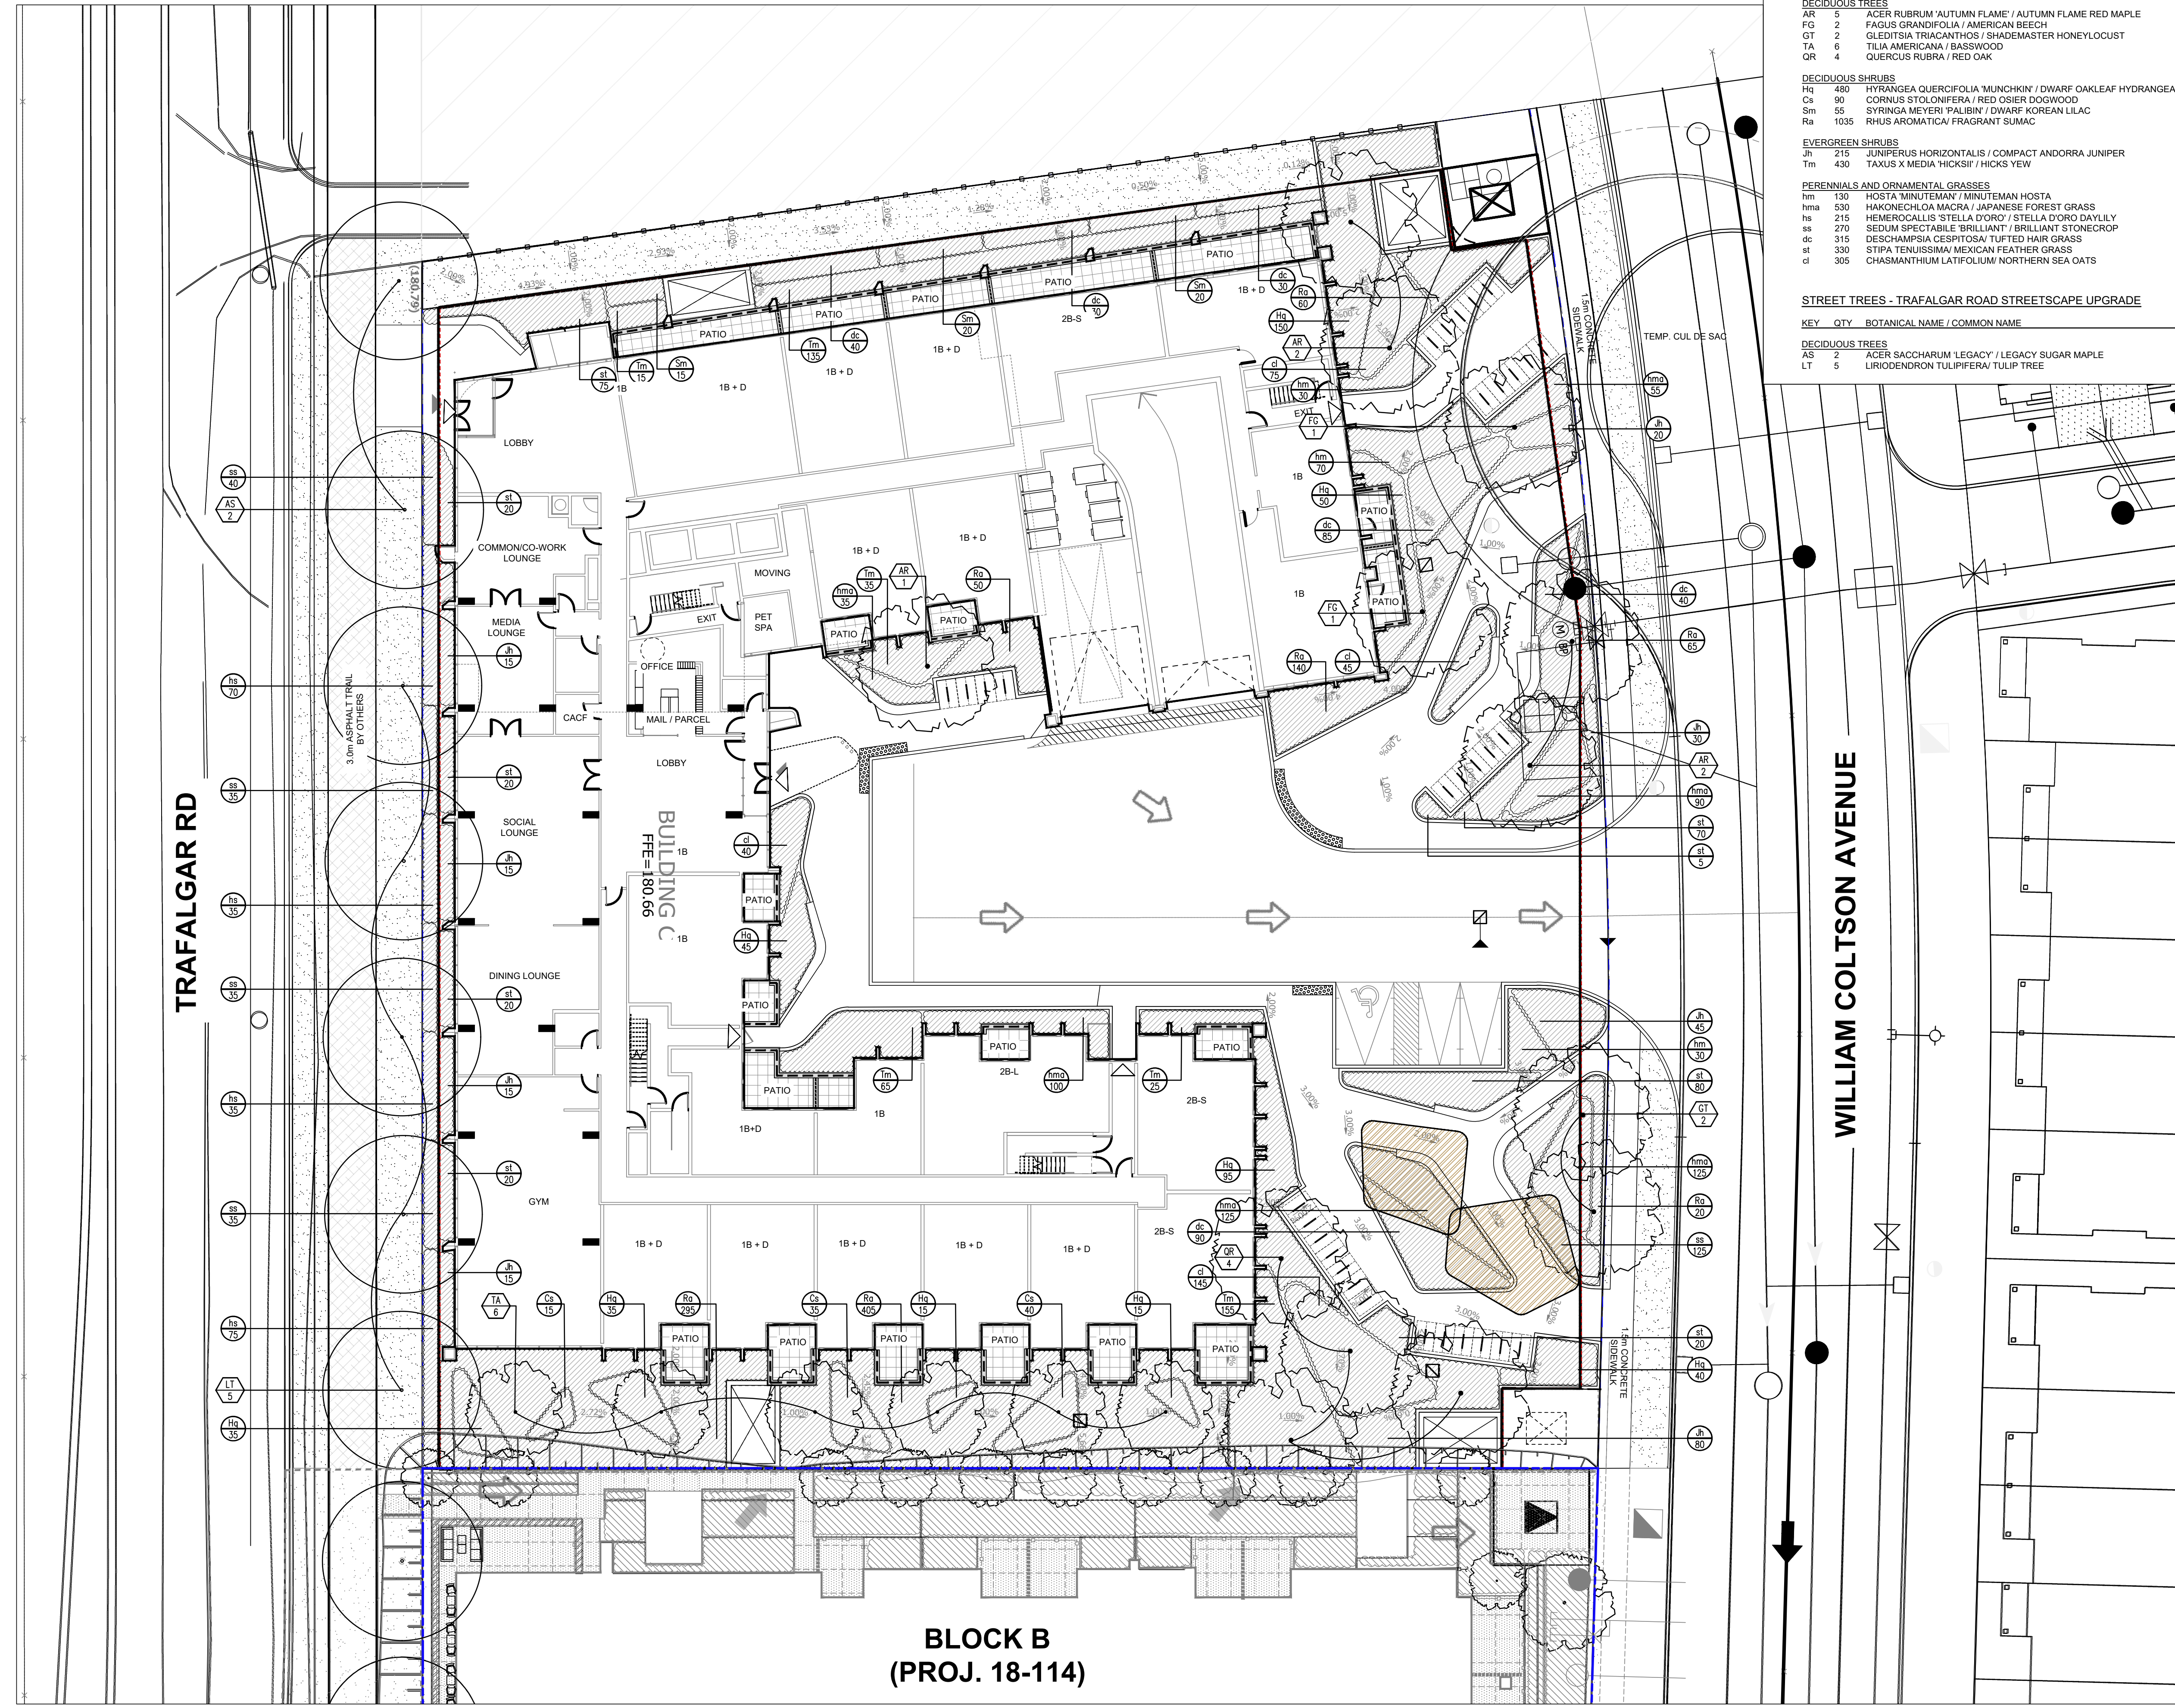

**PROPOSED PLANT LIST**

KEY	QTY	BOTANICAL NAME / COMMON NAME	SIZE / REMARKS
<b>DECIDUOUS TREES</b>			
AR	5	ACER RUBRUM 'AUTUMN FLAME' / AUTUMN FLAME RED MAPLE	60MM CAL. / W.B.
FG	2	FAGUS GRANDIFOLIA / AMERICAN BEECH	60MM CAL. / W.B.
GT	2	GLEDITSIA TRIACANTHOS / SHADEMASTER HONEYLOCUST	60MM CAL. / W.B.
TA	6	TILIA AMERICANA / BASSWOOD	60MM CAL. / W.B.
QR	4	QUERCUS RUBRA / RED OAK	60MM CAL. / W.B.
<b>DECIDUOUS SHRUBS</b>			
Hq	480	HYDRANGEA QUERCIFOLIA 'MUNCHKIN' / DWARF OAKLEAF HYDRANGEA	60 CM HT. POTTED (P/S)
Cs	90	CORNUS STOLONIFERA / RED OSIER DOGWOOD	60 CM HT. POTTED (FS)
Sm	55	SYRINGA MEYERI 'PALIBIN' / DWARF KOREAN LILAC	50 CM HT. POTTED (P/S)
Ra	1035	RHUS AROMATICA / FRAGRANT SUMAC	60 CM HT. POTTED (A)
<b>EVERGREEN SHRUBS</b>			
Jh	215	JUNIPERUS HORIZONTALIS / COMPACT ANDORRA JUNIPER	60 CM HT. POTTED (P/S)
Tm	430	TAXUS X MEDIA 'HICKSII' / HICKS YEW	60 CM HT. POTTED (A)
<b>PERENNIALS AND ORNAMENTAL GRASSES</b>			
hm	130	HOSTA 'MINUTEMAN' / MINUTEMAN HOSTA	1 GAL. POT (S/I)
hma	530	HAKONECHLOA MACRA / JAPANESE FOREST GRASS	1 GAL. POT (A)
he	215	HEMEROCALLIS 'STELLA D'ORO' / STELLA D'ORO DAYLILY	1 GAL. POT (FS)
se	270	SEDUM SPECTABILE 'BRILLIANT' / BRILLIANT STONECROP	1 GAL. POT (FS)
dc	315	DESCHAMPSIA CESPITOSA / TUFTED HAIR GRASS	1 GAL. POT (P/S)
st	330	STIPA TENUISSIMA / MEXICAN FEATHER GRASS	1 GAL. POT (FS)
cl	305	CHASMANTHUM LATIFOLIUM / NORTHERN SEA OATS	1 GAL. POT (P/S)
<b>STREET TREES - TRAFALGAR ROAD STREETSCAPE UPGRADE</b>			
KEY	QTY	BOTANICAL NAME / COMMON NAME	SIZE / REMARKS
<b>DECIDUOUS TREES</b>			
AS	2	ACER SACCHARUM 'LEGACY' / LEGACY SUGAR MAPLE	60MM CAL. / W.B.
LT	5	LIRIODENDRON TULIPIFERA / TULIP TREE	60MM CAL. / W.B.

Contractor shall check all dimensions on the work and report any discrepancy to the Landscape Architect before proceeding. All drawings and specifications are the property of the Landscape Architect and must be returned at the completion of the work. This drawing is not to be used for construction until signed by the Landscape Architect.

**LEGEND**

- PROPERTY LINE
- LIMIT OF SLAB
- WOOD PRIVACY RAILING 1.2HT
- WOOD PRIVACY PANEL 1.8HT
- DECORATIVE METAL FENCE 1.2HT

**PLANTING**

- MULTI-STEM TREE
- DECIDUOUS TREE
- CONIFEROUS TREE
- SHRUBS
- LIMIT OF BED

**SURFACE TREATMENT**

- SOD

**DETAIL KEY**

- DETAIL NO.
- SHEET NO.

**PLANTING KEY**

- TREE SPECIES QUANTITY
- SHRUB SPECIES QUANTITY

1	Issued for SPA 1 Submission	Dec. 10/21
No.	Description	Date
Revision		

City Approval Stamp

**NAK**  
design strategies

421 RONCESVALLES AVENUE, TORONTO, ON M6R 2N1 CANADA  
T 416.340.8700 F 416.340.7100 [NAKDESIGNSTRATEGIES.COM](http://NAKDESIGNSTRATEGIES.COM)

Project

**OAKVILLE**  
BLOCK 14

Title

**PLANTING PLAN**

Date	Oct. 06, 2021	Sheet	
Scale	1:200		
Drawn	TFG		
Checked	PD		
Job No.	21207		


**L1.1**

**BLOCK B**  
**(PROJ. 18-114)**



Contractor shall check all dimensions on the work and report any discrepancy to the Landscape Architect before proceeding. All drawings and specifications are the property of the Landscape Architect and must be returned at the completion of the work. This drawing is not to be used for construction until signed by the Landscape Architect.

Key Plan

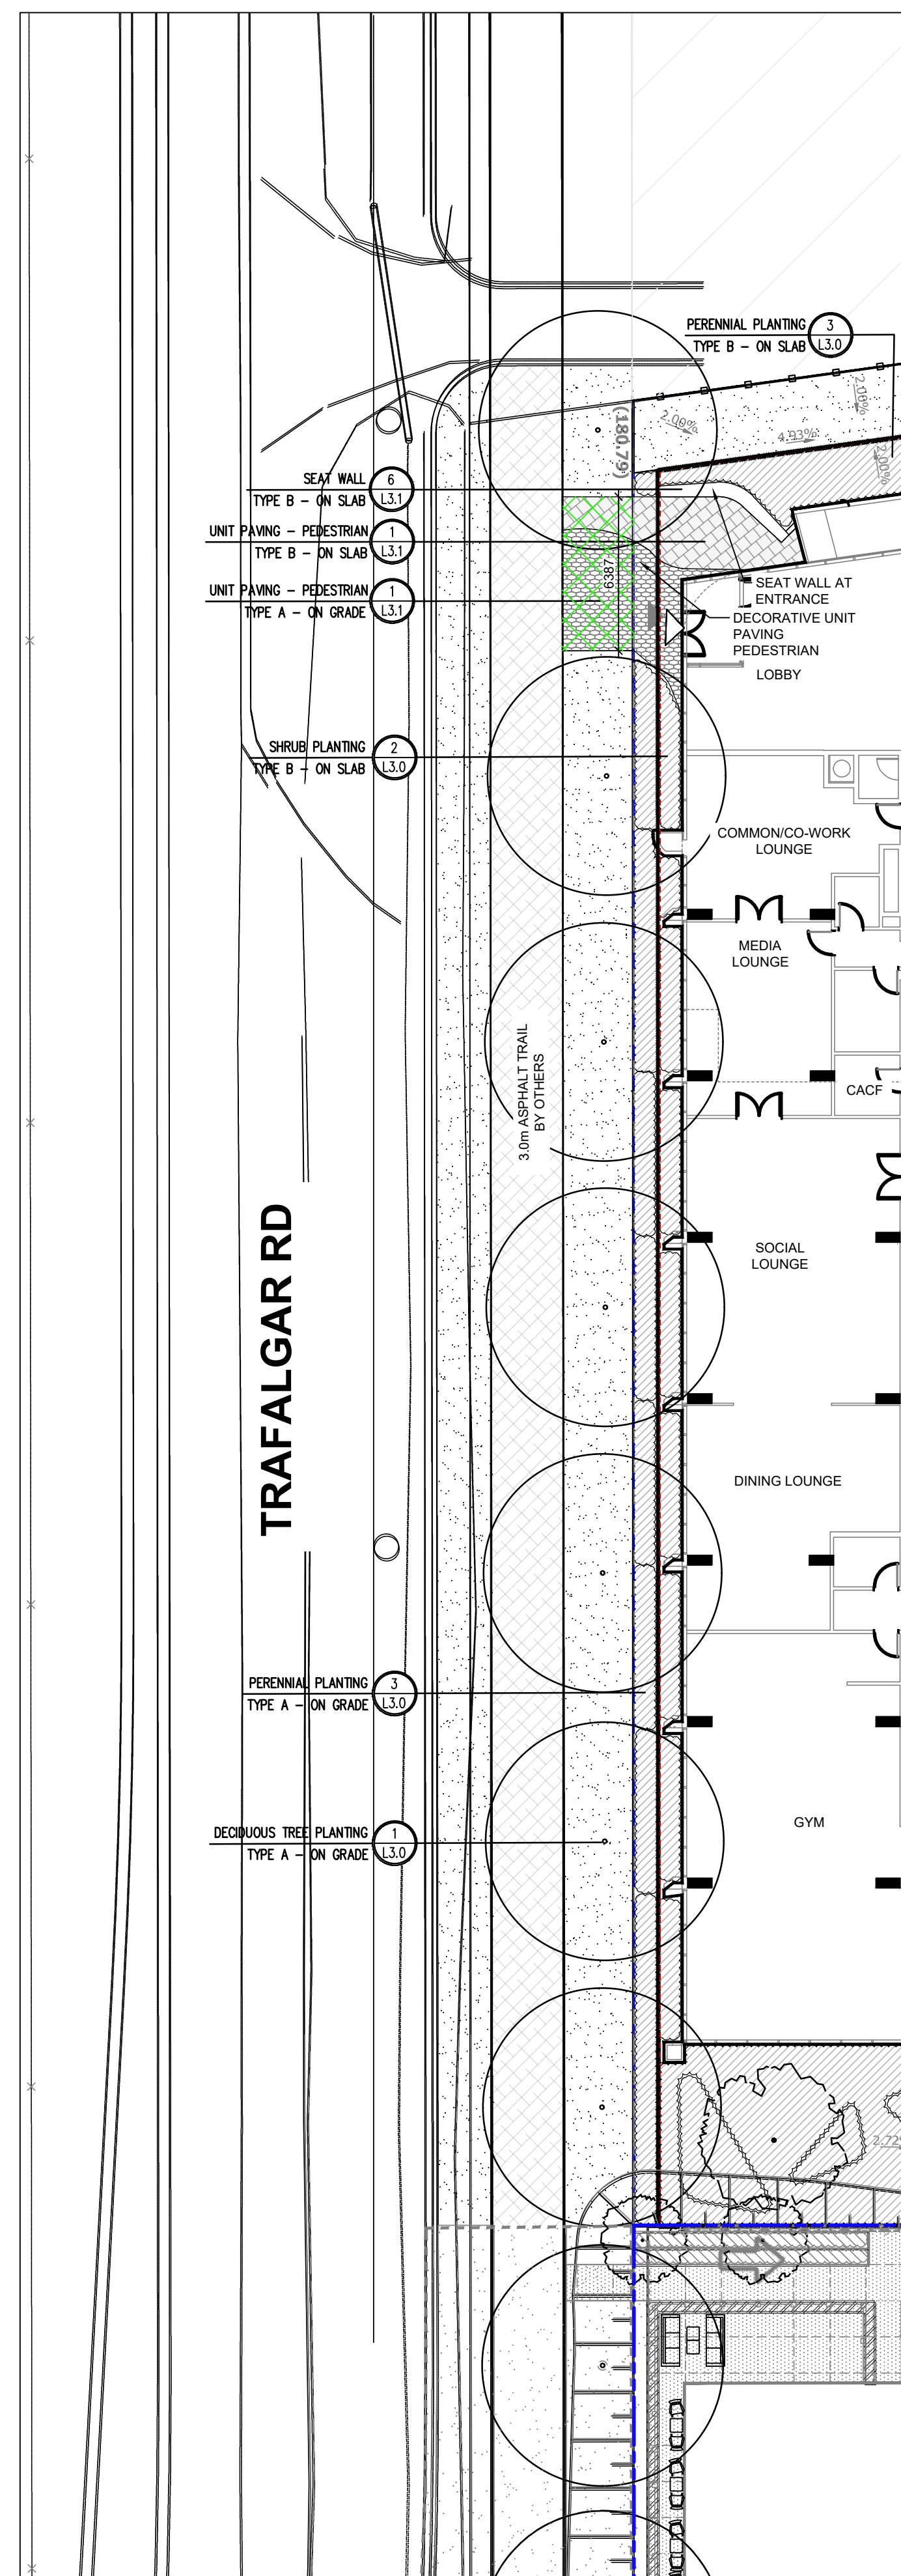

**LEGEND**


- PROPERTY LINE
- LIMIT OF SLAB
- WOOD PRIVACY RAILING 1.2HT
- WOOD PRIVACY PANEL 1.8HT
- DECORATIVE METAL FENCE 1.2HT
- SURFACE TREATMENT**
- UNIT PAVING TYPE 1: TECHO BLOC Under Design Review SIZE: 100 X 150 X 450 PATTERN: RUNNING BOND
- UNIT PAVING TYPE 2: HEXA 100 BY TECHO BLOC SIZE: 100 X 230 X 385 PATTERN: HEXAGON PATTERN
- ASPHALT PAVING - MULTI USE TRAIL

**DETAIL KEY**

- DETAIL NO.
- SHEET NO.

- 1) FOR ALL SITE GRADING REFER TO CIVIL PLANS
- 2) PROPOSED UNIT PAVING WALKWAYS LINKING THE PEDESTRIAN ENTRY WAYS FROM THE BUILDING TO THE REGIONS MULTIUSE TRAIL WILL BE INSTALLED AFTER THE MUT IS COMPLETED BY THE REGION. PLEASE REFER TO ULTIMATE DRAWING L1.

No.	Description	Date
1	Issued for SPA 1 Submission	Dec. 10/21
Revision		
City Approval Stamp		

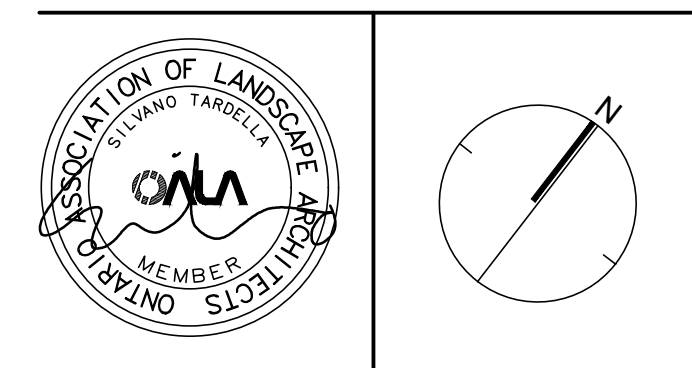

**NAK**  
design strategies

421 RONCESVALLES AVENUE, TORONTO, ON M6R 2N1 CANADA  
T 416.340.8700 F 416.340.7100 [NAKDESIGNSTRATEGIES.COM](http://NAKDESIGNSTRATEGIES.COM)

Project

**OAKVILLE**  
BLOCK 14


Title  
**INTERIM STREETScape PLAN**  
TRAFALGAR ROAD

Date	Oct. 06, 2021	Sheet	<b>L1.3</b>
Scale	1:200		
Drawn	TFG		
Checked	PD		
Job No.	21207		



Contractor shall check all dimensions on the work and report any discrepancy to the Landscape Architect before proceeding. All drawings and specifications are the property of the Landscape Architect and must be returned at the completion of the work. This drawing is not to be used for construction until signed by the Landscape Architect.

Key Plan

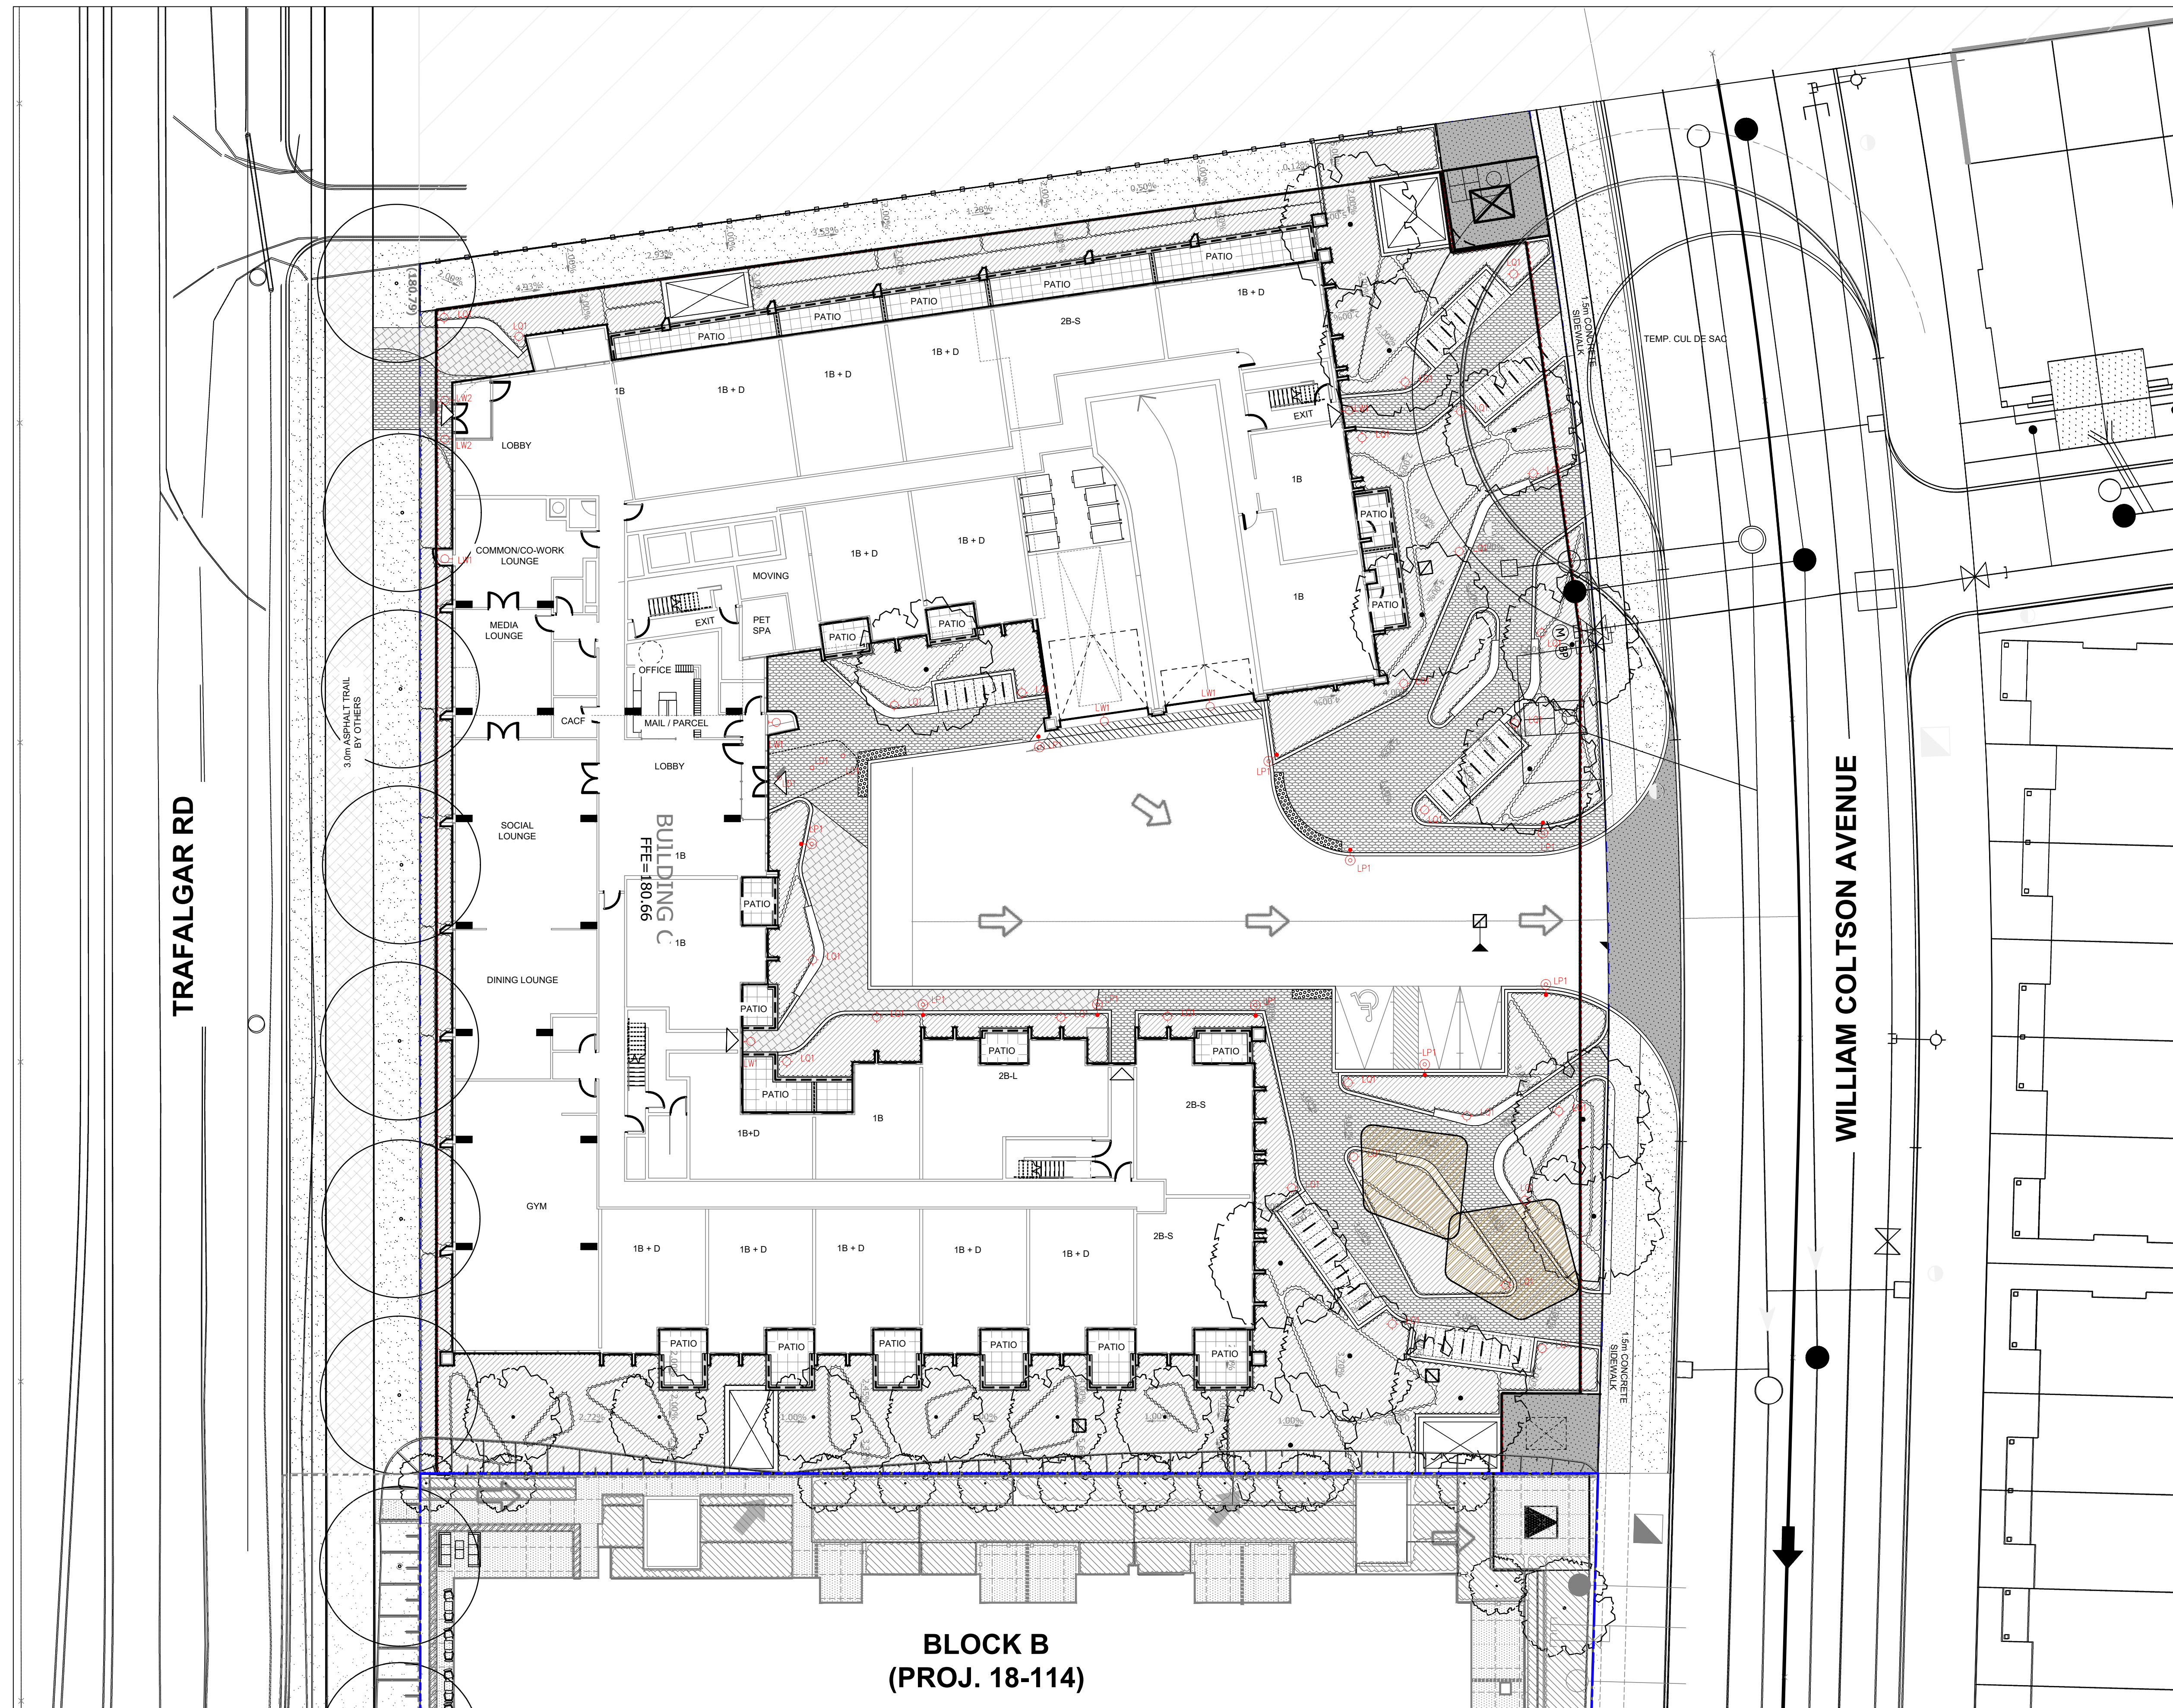

**LEGEND**


- PROPERTY LINE
- - - LIMIT OF SLAB
- WOOD PRIVACY RAILING 1.2HT
- WOOD PRIVACY PANEL 1.8HT
- DECORATIVE METAL FENCE 1.2HT

**SITE LIGHTING**

- LW1 CEILING LIGHT
- LW2 WALL SCONCE LIGHT
- LW3 WALL SCONCE LIGHT
- LP1 LIGHT POLE
- LB1 LIGHT BOLLARD

FOR ALL LIGHTING REFER TO ELEC. CONSULTANT PLANS

1	Issued for SPA 1 Submission	Dec 10/21
No.	Description	Date
Revision		
City Approval Stamp		

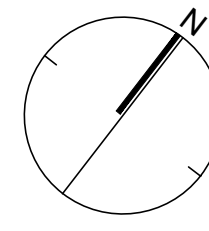

**NAK**  
design strategies

421 RONCESVALLES AVENUE, TORONTO, ON M6R 2N1 CANADA  
T 416.340.8700 F 416.340.7100 [NAKDESIGNSTRATEGIES.COM](http://NAKDESIGNSTRATEGIES.COM)

Project

**OAKVILLE**  
BLOCK 14

Title  
**LIGHTING PLAN**

Date	Oct. 06, 2021	Sheet	
Scale	1:200		
Drawn	TFG		
Checked	PD		
Job No.	21207		

**LT**

**BLOCK B**  
**(PROJ. 18-114)**